

REVISIONS	DESCRIPTION



ISSUED FOR BID

FIRST FLOOR PLAN - MECHANICAL

MARK	DATE	DESCRIPTION

SHEET TITLE

JOB NO.	2321.02
DATE	12.1.2016
DWN. BY	LSH
SHEET NO.	M2.1

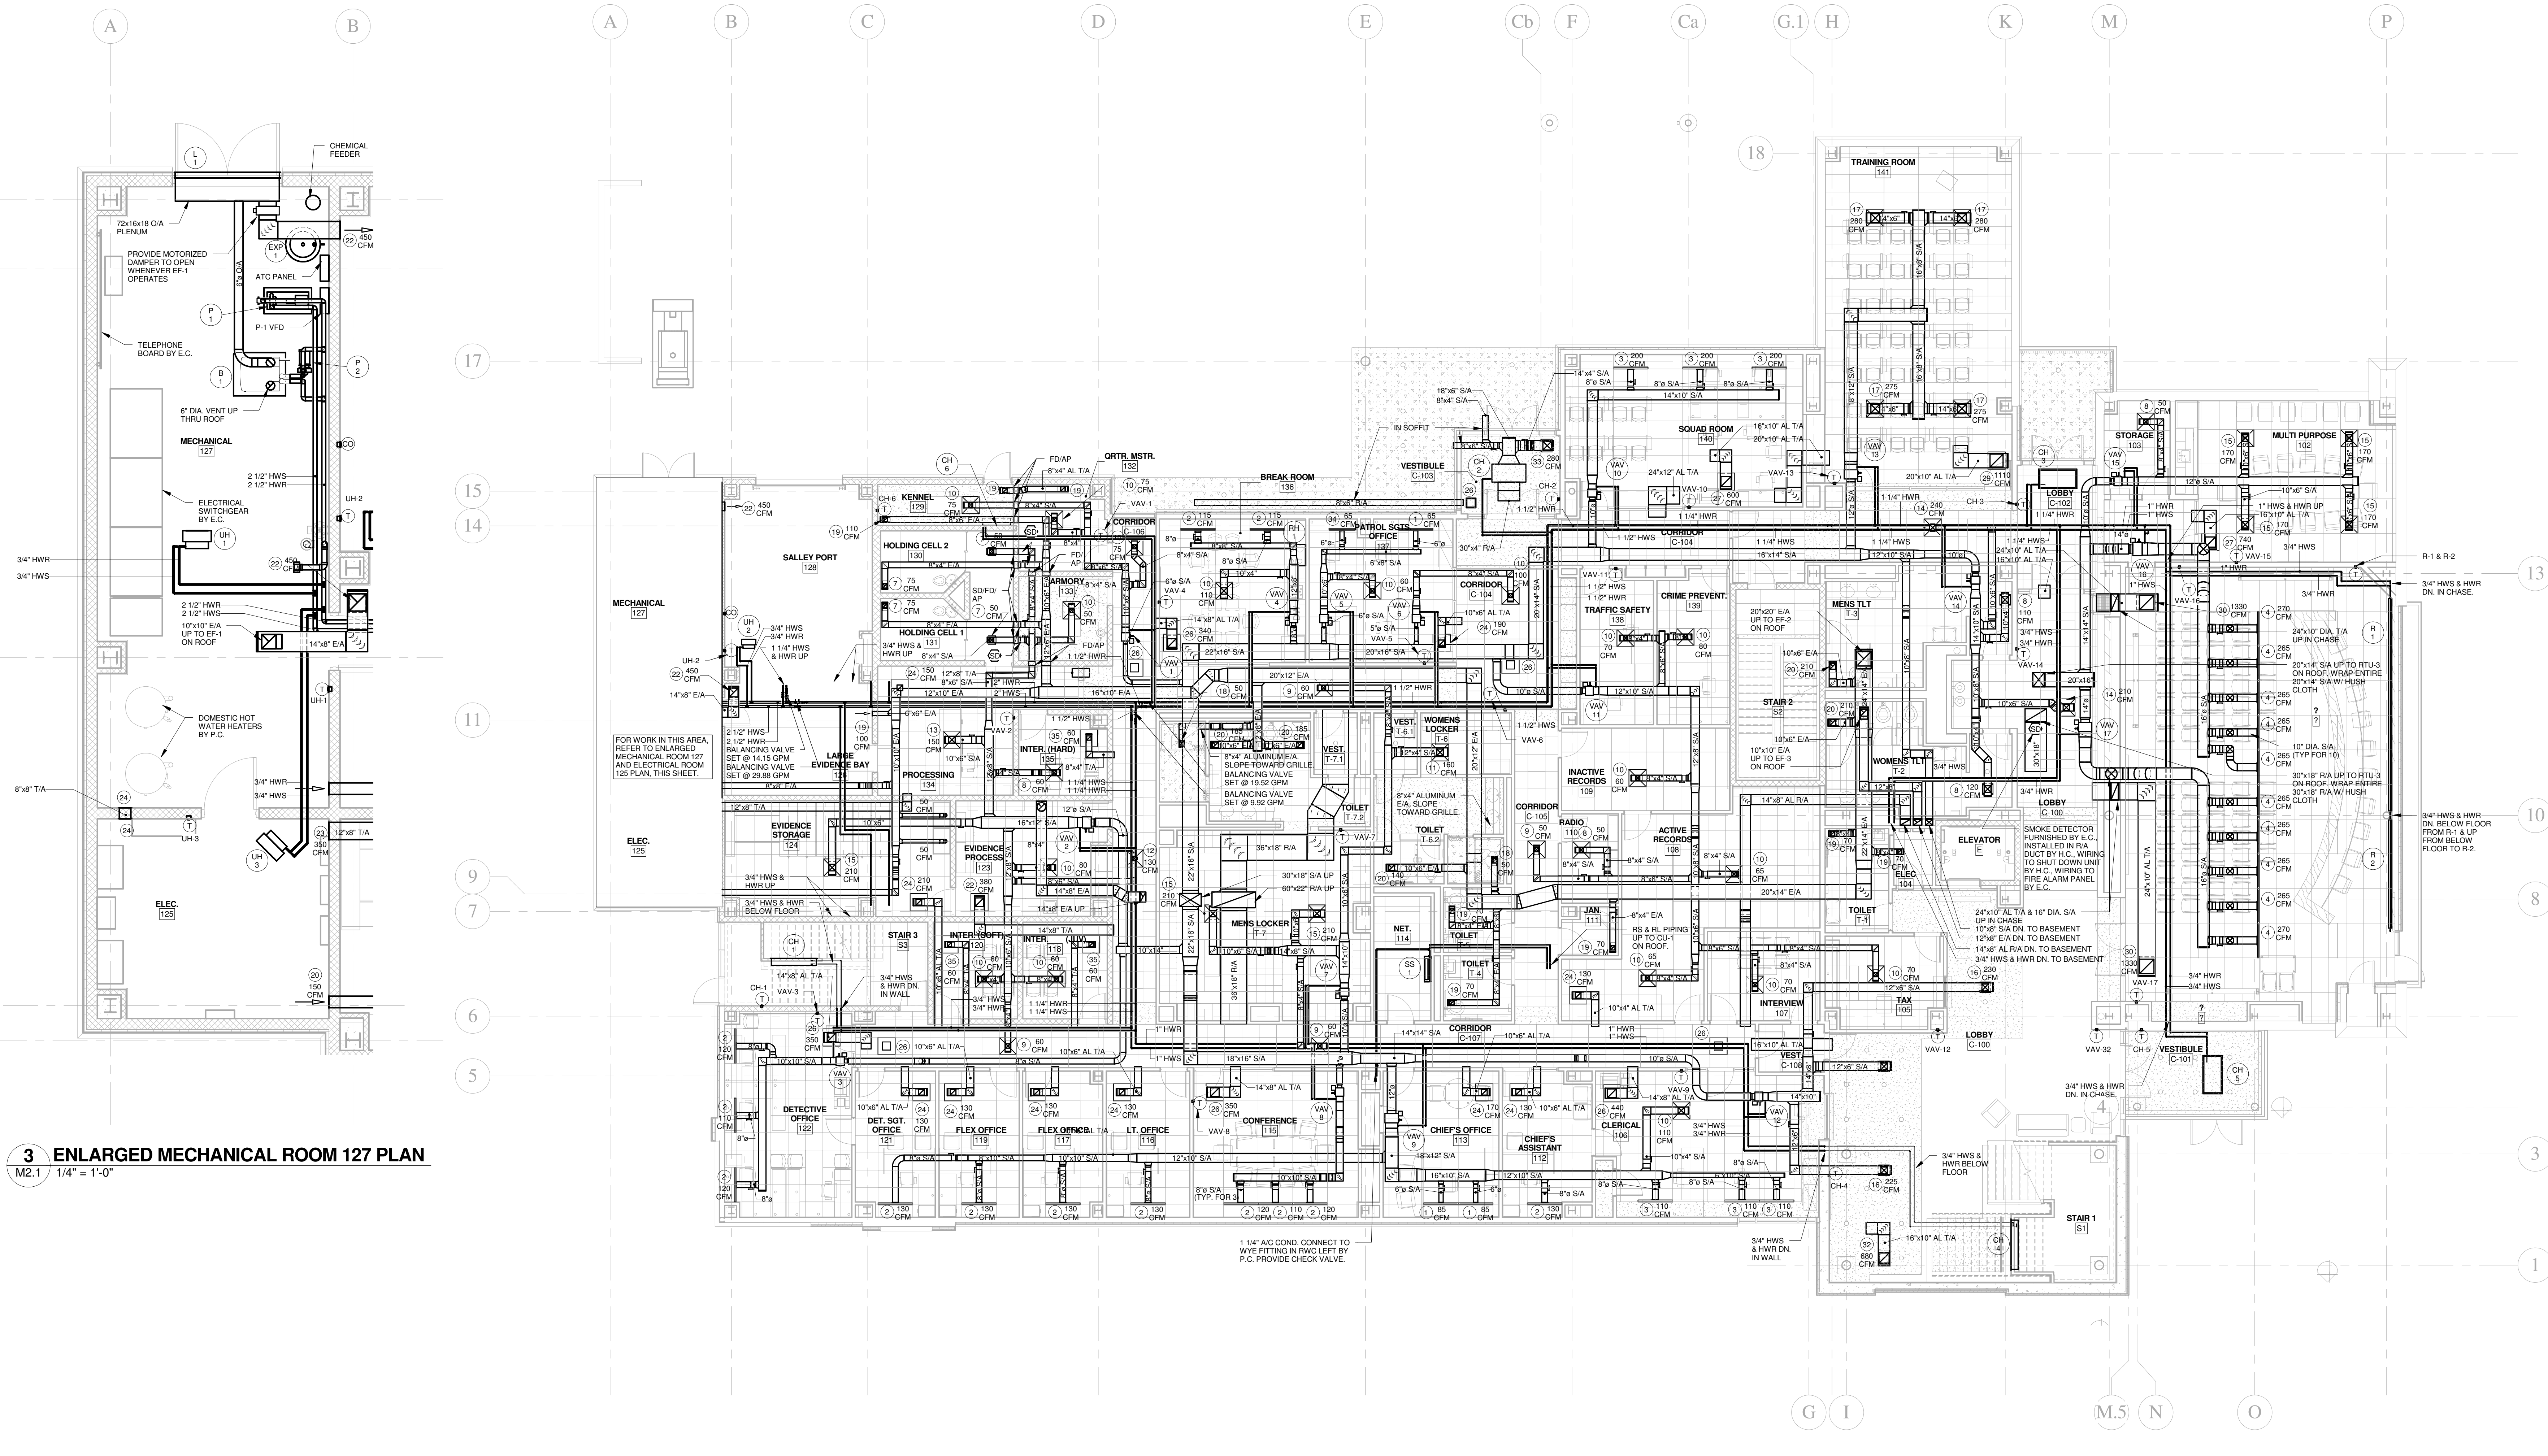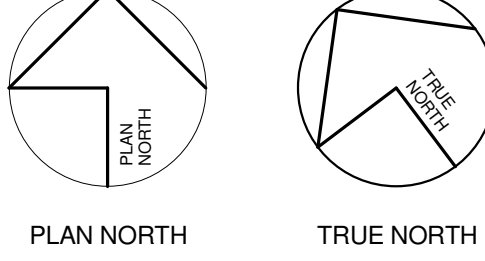

**3 ENLARGED MECHANICAL ROOM 127 PLAN**  
 M2.1 1/4" = 1'-0"

**1 FIRST FLOOR PLAN - MECHANICAL**  
 M2.1 1/8" = 1'-0"

NOTES:  
 1. ALL DUCTWORK DOWNSTREAM OF VAV BOXES SHALL BE ACoustically LINED WITH 1 1/2" LINER.  
 ALL RETURN AIR & TRANSFER AIR DUCTWORK SHALL BE ACoustically LINED WITH 1" LINER. PROVIDE 3'-0" CLEARANCE FOR ACCESS TO CONTROL PANELS AT ALL VAV BOXES.  
 2. ALL HWS & HWR PIPING FEEDING VAV BOXES SHALL BE 3/4", UNLESS NOTED OTHERWISE.