


NOTES :

1. REFER TO DRAWING MPE-1 FOR HVAC, PLUMBING/FIRE PROTECTION & ELECTRICAL, GENERAL NOTES, ABBREVIATIONS, LEGENDS & DRAWING LIST.
2. UNLESS OTHERWISE NOTED, ALL CIRCUITS SHALL HAVE DEDICATED NEUTRAL.
3. ALL EXIT SIGNS, EMERGENCY BATTERY PACKS & EMERGENCY LIGHTING FIXTURES (NOTED "EM") SHALL BE UNSWITCHED AND CONNECTED AHEAD OF ANY LIGHTING CONTROL DEVICES.
4. UNLESS OTHERWISE NOTED, ALL 120 VOLT, SINGLE PHASE CIRCUIT SHALL HAVE 2#12, 1#12G IN 3/4" AS A MINIMUM. ALL 120 VOLT, 20A SINGLE PHASE CIRCUITS OVER 80 FT. IN LENGTH AND 277V 20A CIRCUITS GREATER THAN 200 FT. IN LENGTH SHALL BE 2#10, 1#10G IN 3/4".
5. UNLESS OTHERWISE NOTED, ALL 277 VOLT, SINGLE PHASE CIRCUIT SHALL HAVE 2#12, 1#12G IN 3/4" AS A MINIMUM. ALL 277 VOLT, 20A SINGLE PHASE CIRCUITS GREATER THAN 200 FT. IN LENGTH SHALL BE 2#10, 1#10G IN 3/4".
6. REFER TO THE LIGHTING CONTROL PANEL SCHEDULE LCP-1 FOR ALL LIGHTING CIRCUIT INFORMATION.
7. REFER TO LIGHTING DESIGNER DRAWING SET FOR ADDITIONAL INFORMATION.
8. WHERE FIXTURES ARE NOTED "EM" SHALL BE FURNISHED WITH EMERGENCY BATTERY PACKS AS STANDARD.
9. ALL LIGHT FIXTURES SHOWN ON THE GRADE LEVEL REFLECTED CEILING PLAN SHALL BE INSTALLED ABOVE THE REGULATORY FLOOR ELEVATION.

DRAWING NOTES :

1. REFER TO POWER & SYSTEM PLANS FOR CIRCUIT INFO ON WALK-IN LIGHTS.
2. CEILING PENETRATION TO EXTEND LIGHTING CONDUITS ABOVE CEILING.
3. CEILING MOUNTED VACANCY SENSORS SHALL OPERATE IN TANDEM WITH THE LOCAL SWITCHING TO PROVIDE "AUTO-OFF" FUNCTIONALITY.
4. LOCAL LOW VOLTAGE SWITCHING TO PROVIDE "MANUAL-OFF" FUNCTIONALITY FOR FIXTURES ALSO CONTROLLED VIA VACANCY SENSORS.
5. PROVIDE WATERPROOF / WEATHERPROOF SINGLE-GANG BOX AND SWITCH COVER FOR LOW-VOLTAGE WALL SWITCH.
6. PROVIDE NEMA-4 JUNCTION BOX MOUNTED AT HIGH CEILING TO HOUSE REMOTE MAGNETIC BALLAST FOR FIXTURES SHOWN. LIMIT CONDUCTOR LENGTH BETWEEN REMOTE BALLAST AND FIRST FIXTURE ACCORDING TO THE MANUFACTURERS INSTRUCTIONS.
7. MOUNT REMOTE TRANSFORMER (150W) AT HIGH CEILING BENEATH DECK. TRANSFORMER SHALL BE HEVILITE HLT-150 OR APPROVED EQUAL.
8. PROVIDE NEW DIRECT BURIAL TRANSFORMER (100W) IN COMPOSITE ENCLOSURE SUITABLE FOR WET/DRY INSTALLATIONS. TRANSFORMER SHALL BE HEVILITE HLT-08-100 OR APPROVED EQUAL.
9. PROVIDE SINGLE PHASE NEMA-3R, 30A/52AF DISCONNECT SWITCH. SWITCH SHALL BE LOCKABLE.
10. PROVIDE SINGLE PHASE NEMA-3R, 30A/53AF DISCONNECT SWITCH.
11. PROVIDE REMOTE POWER SUPPLY AND MOUNT WITHIN STORAGE ROOM AS SHOWN. REMOTE POWER SUPPLY SHALL BE BY EDGE LIGHTING PSB-XX-010-24VDC OR APPROVED EQUAL.
12. CIRCUIT BREAKERS FOR LIGHTING CIRCUITS LCP-15, LCP-16, CLP-19 AND CLP-120 SHALL BE ABLE TO BE SWITCHED OFF IN CASE OF FLOOD. CIRCUIT THE LIGHT FIXTURES AS NOTED ON THE DRAWING. DO NOT CONNECT OTHER LIGHT FIXTURES TO THESE CIRCUITS.

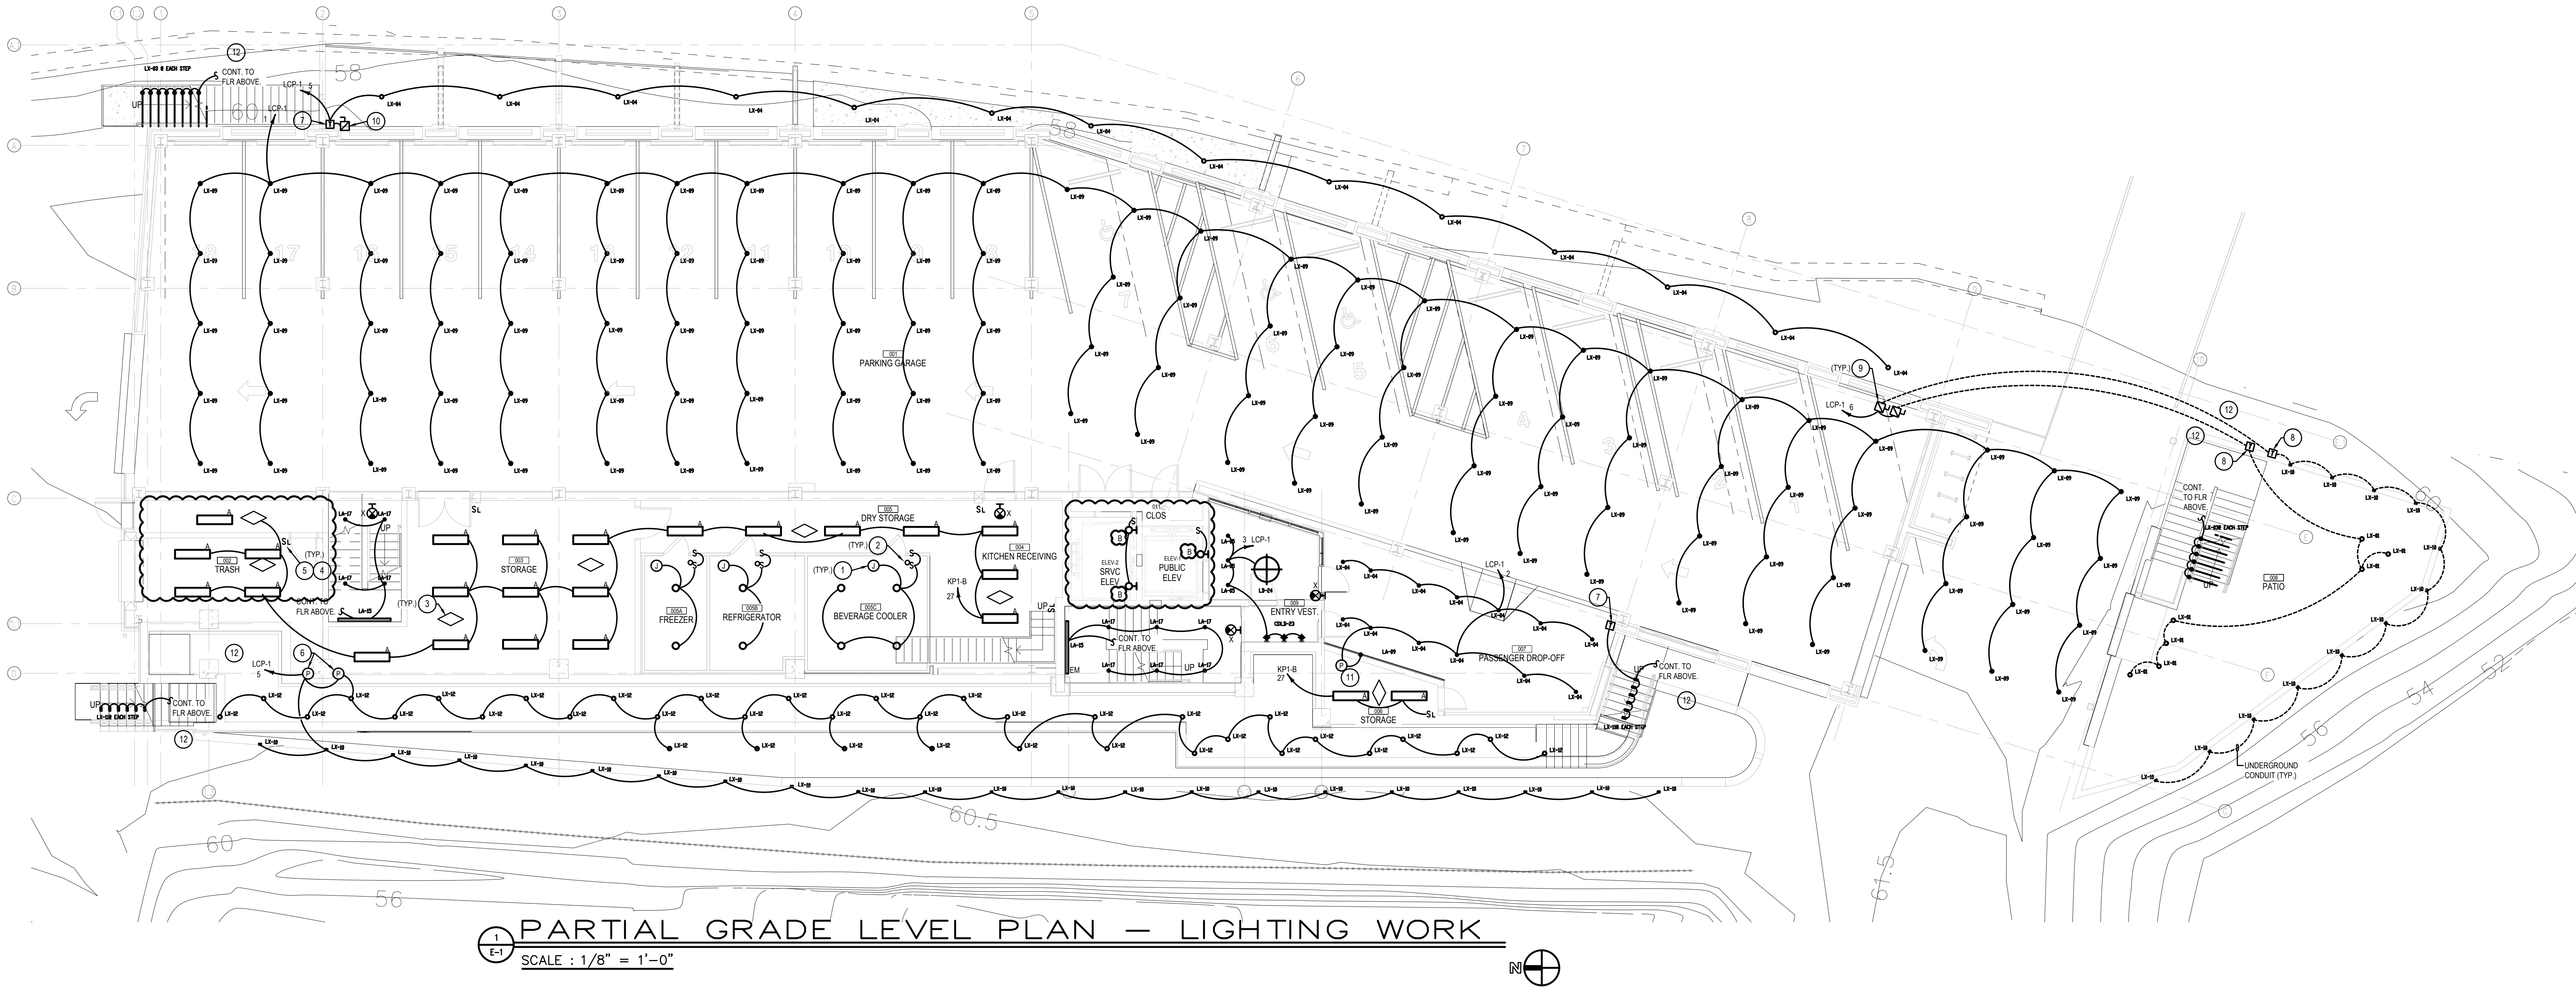

RIVERHOUSE AT
Odette's

274 SOUTH RIVER ROAD
NEW HOPE, PA 18838

OWNER/ OPERATOR:
GATEWAY TO NEW HOPE, LLC
274 South River Road
New Hope, PA 18838

ARCHITECT:
STOKES ARCHITECTURE
2103 Sansom Street
Philadelphia, PA 19103
tel: (215) 523-9190

INTERIOR DESIGNER
BALONGUE DESIGN INC
707 Mansford Road
Villanova, PA 19085
tel: (610) 525-7593
fax: (610) 525-7594

CIVIL ENGINEER:
VAN CLEEF ENGINEERING
ASSOCIATES, LLC
501 North Main Street
Doylestown, PA 18901
tel: (215) 345-1876
fax: (215) 345-1730

STRUCTURAL ENGINEER:
O'DONNELL & NACCARATO
111 S. Independence Mall East Suite 950
Philadelphia, PA 19106
tel: (215) 925-3788

MEP ENGINEER:
WICK FISHER WHITE
111 S. Independence Mall East Suite 400
Philadelphia, PA 19106
tel: (215) 627-8000
fax: (215) 627-8040

LIGHTING DESIGNER
BRIAN ORTER LIGHTING DESIGN LLC
227 W. 29th St 8th Floor
New York, NY 10001
tel: (646) 502-7568

STOKES.
ARCHITECTURE + DESIGN
STOKESARCH.COM

SEAL

MARK	REVISIONS	DATE
1	90% PRICING SET	06/18/2018
2	PERMIT SET	07/25/2018
3	COMMISSIONING	01/23/2019
3	CONSTRUCTION	02/28/2019

ALL DIMENSIONS AND RELATIONSHIPS MUST BE VERIFIED BY CONTRACTOR. THE ARCHITECT IS TO BE NOTIFIED OF ANY DISCREPANCIES BEFORE PROCEEDING WITH THE CONSTRUCTION. DO NOT SCALE FROM DRAWINGS.

PROJECT # 140145.001
FILENAME: WFW
DRAWN: WFW
CHECKED: WFW
DATE: 07/25/18

ISSUE FOR CONSTRUCTION
02-28-2019

GROUND FLOOR
PLAN-LIGHTING

DRAWING

E-1