



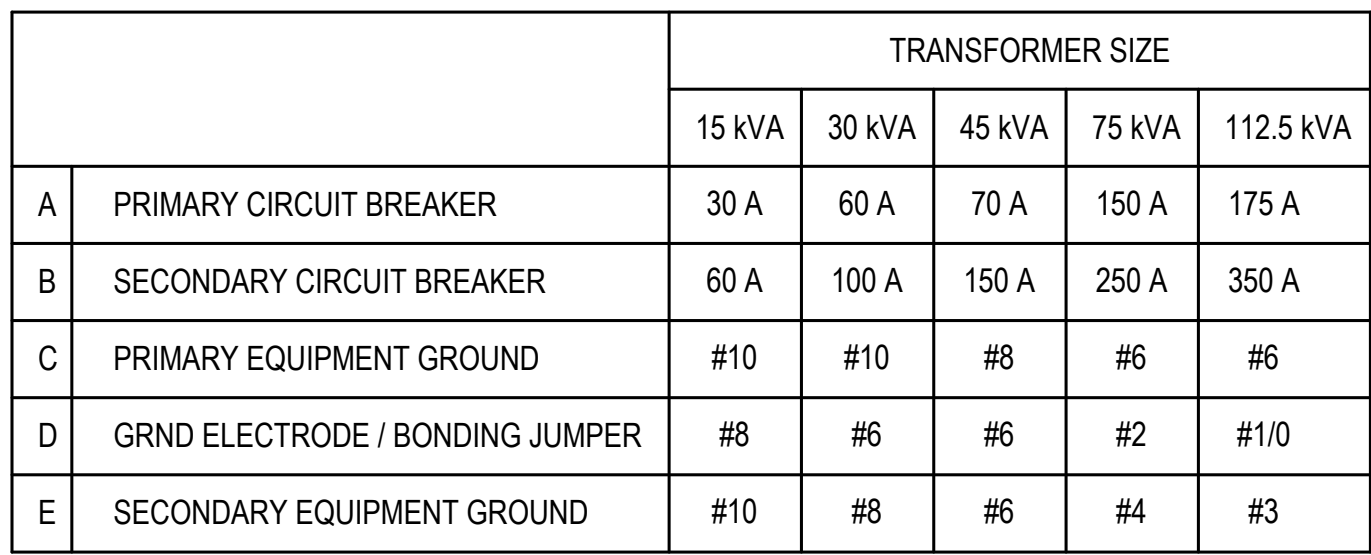


1
E-19

TYPICAL INDOOR TRANSFORMER
GROUNDING DETAIL


TRANSFORMER MOUNTING DETAIL

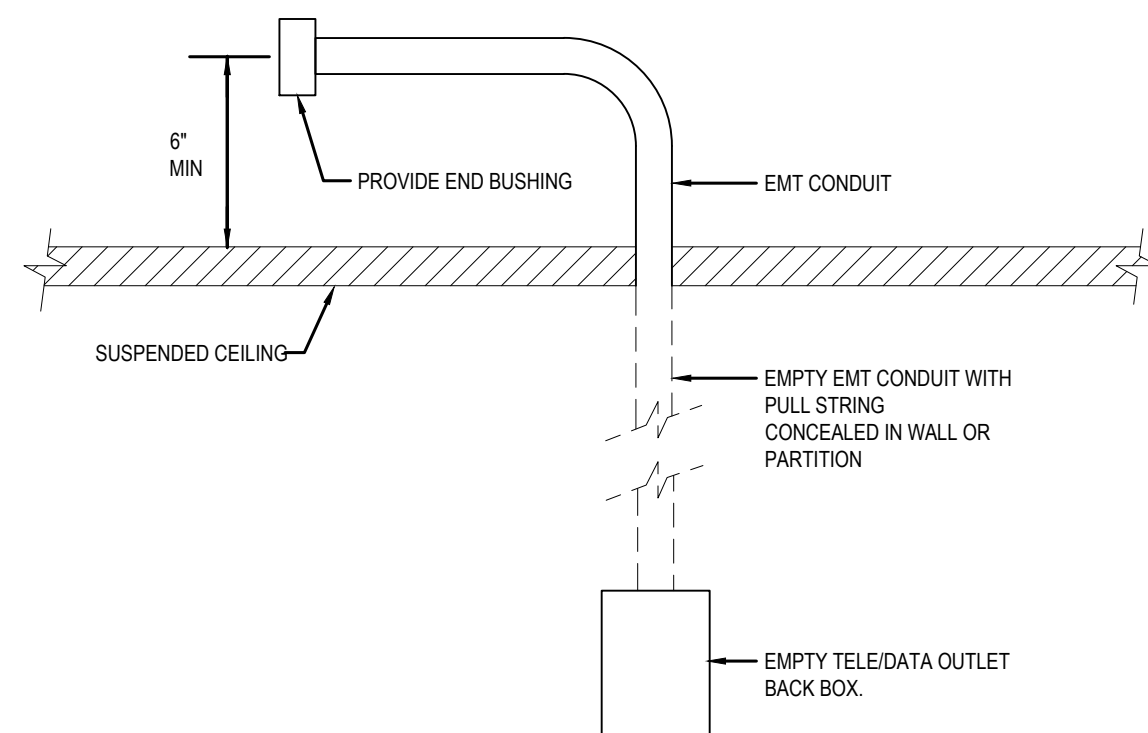


DETAIL- CONDUIT STUB-UP ABOVE ACCESSIBLE CEILING

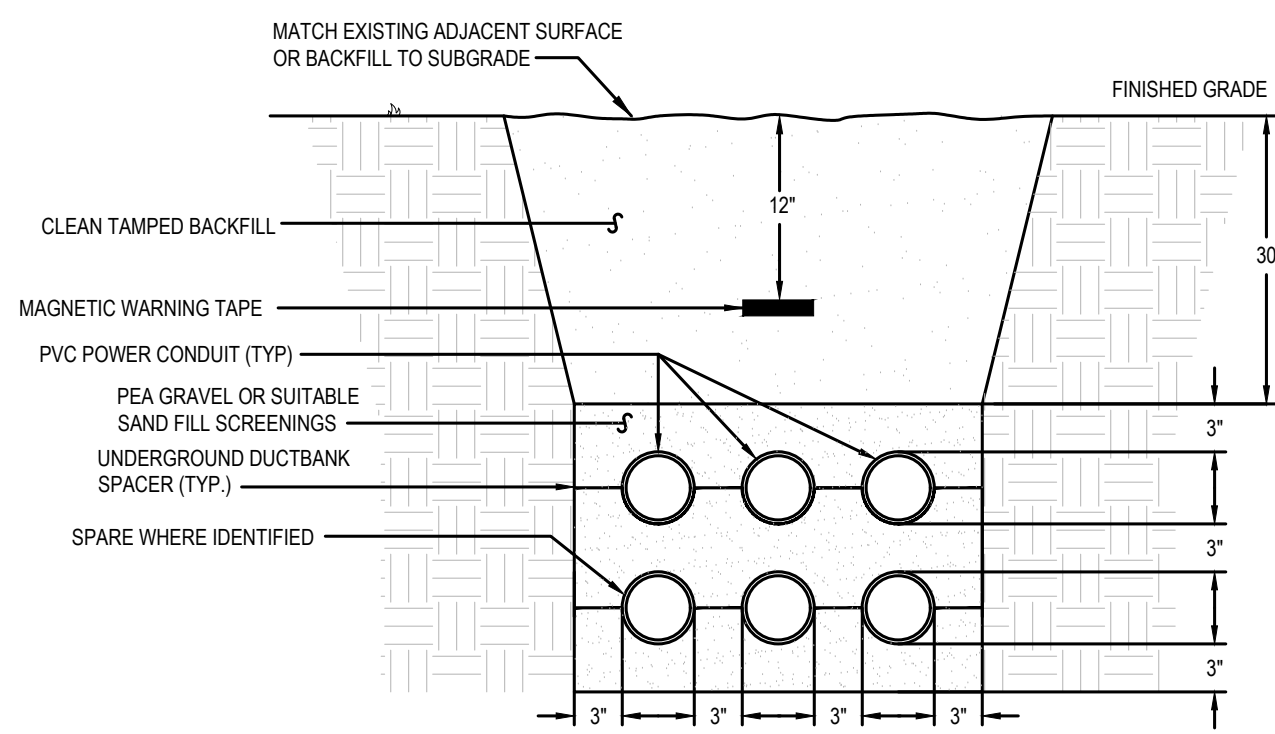



TYPICAL DUCT BANK SECTION

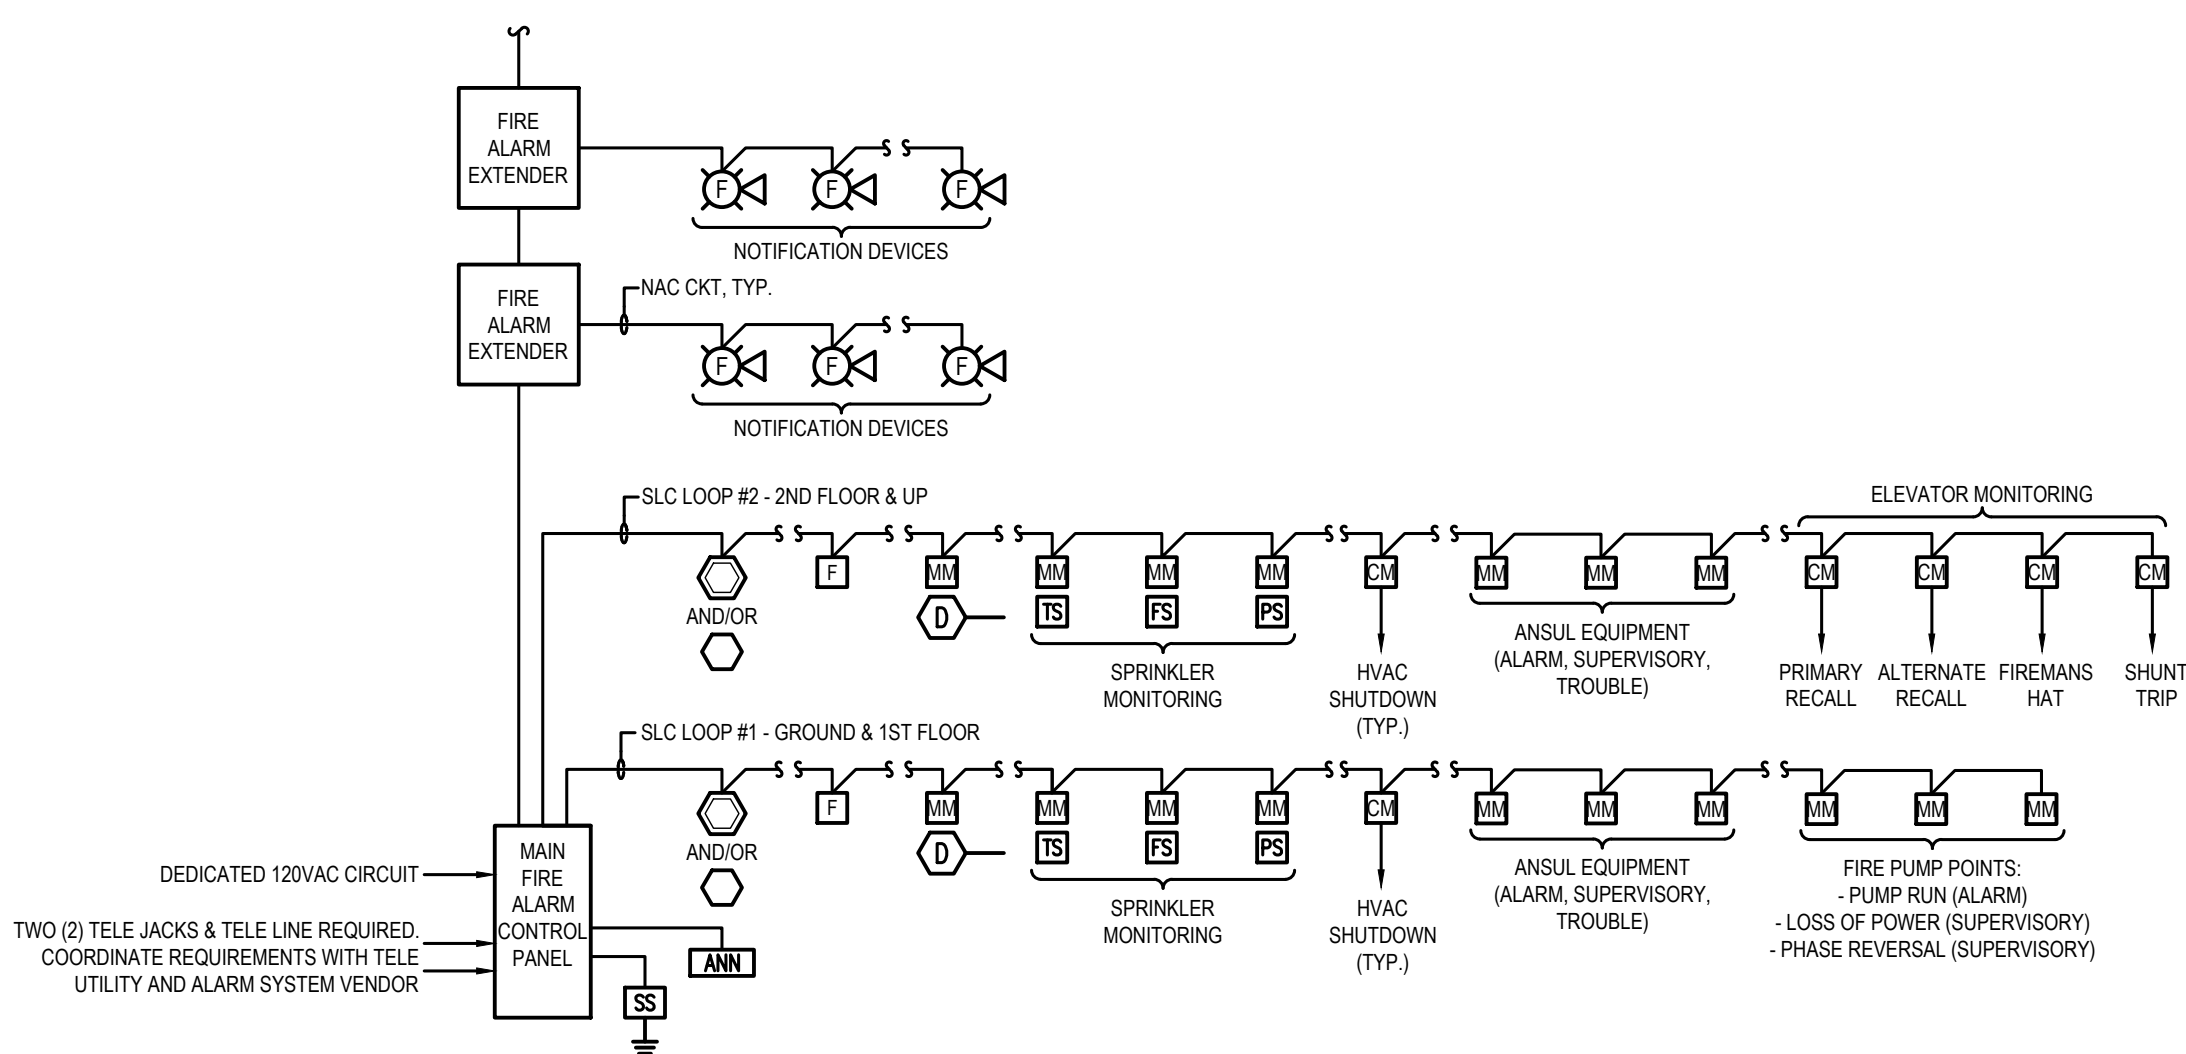

TYPICAL FIRE ALARM RISER DIAGRAM

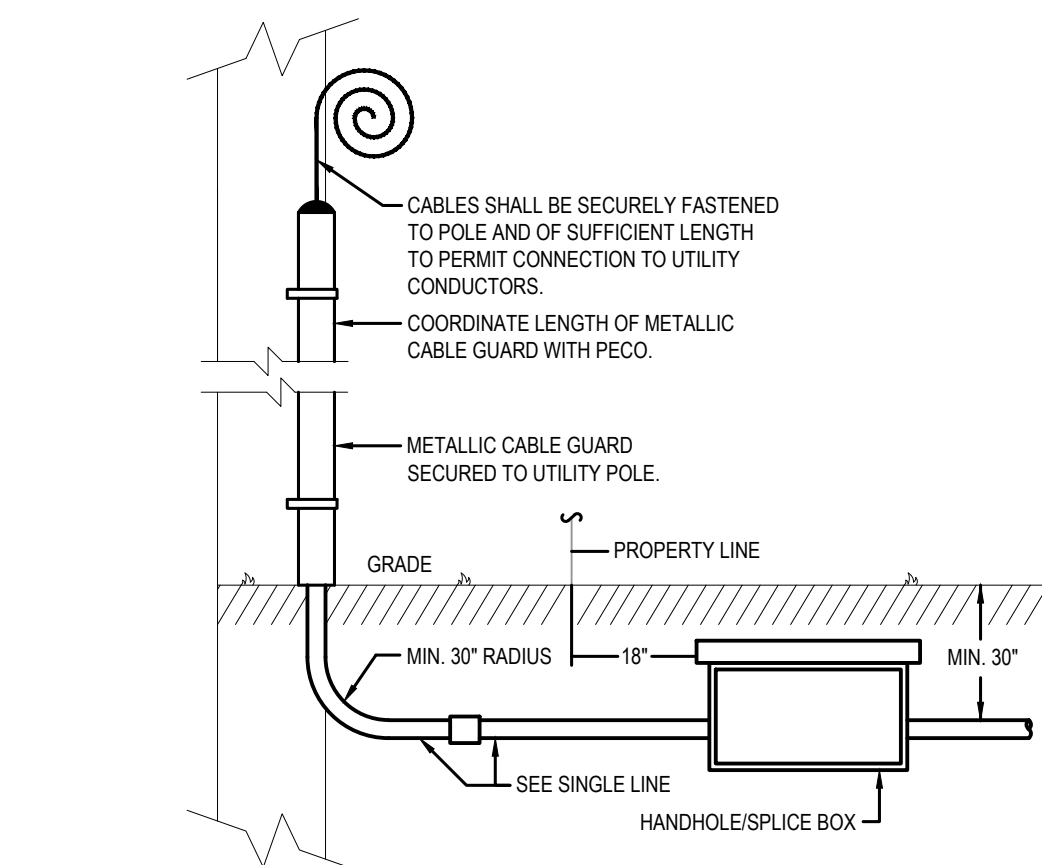

UNDERGROUND SERVICE FROM OVERHEAD LINES

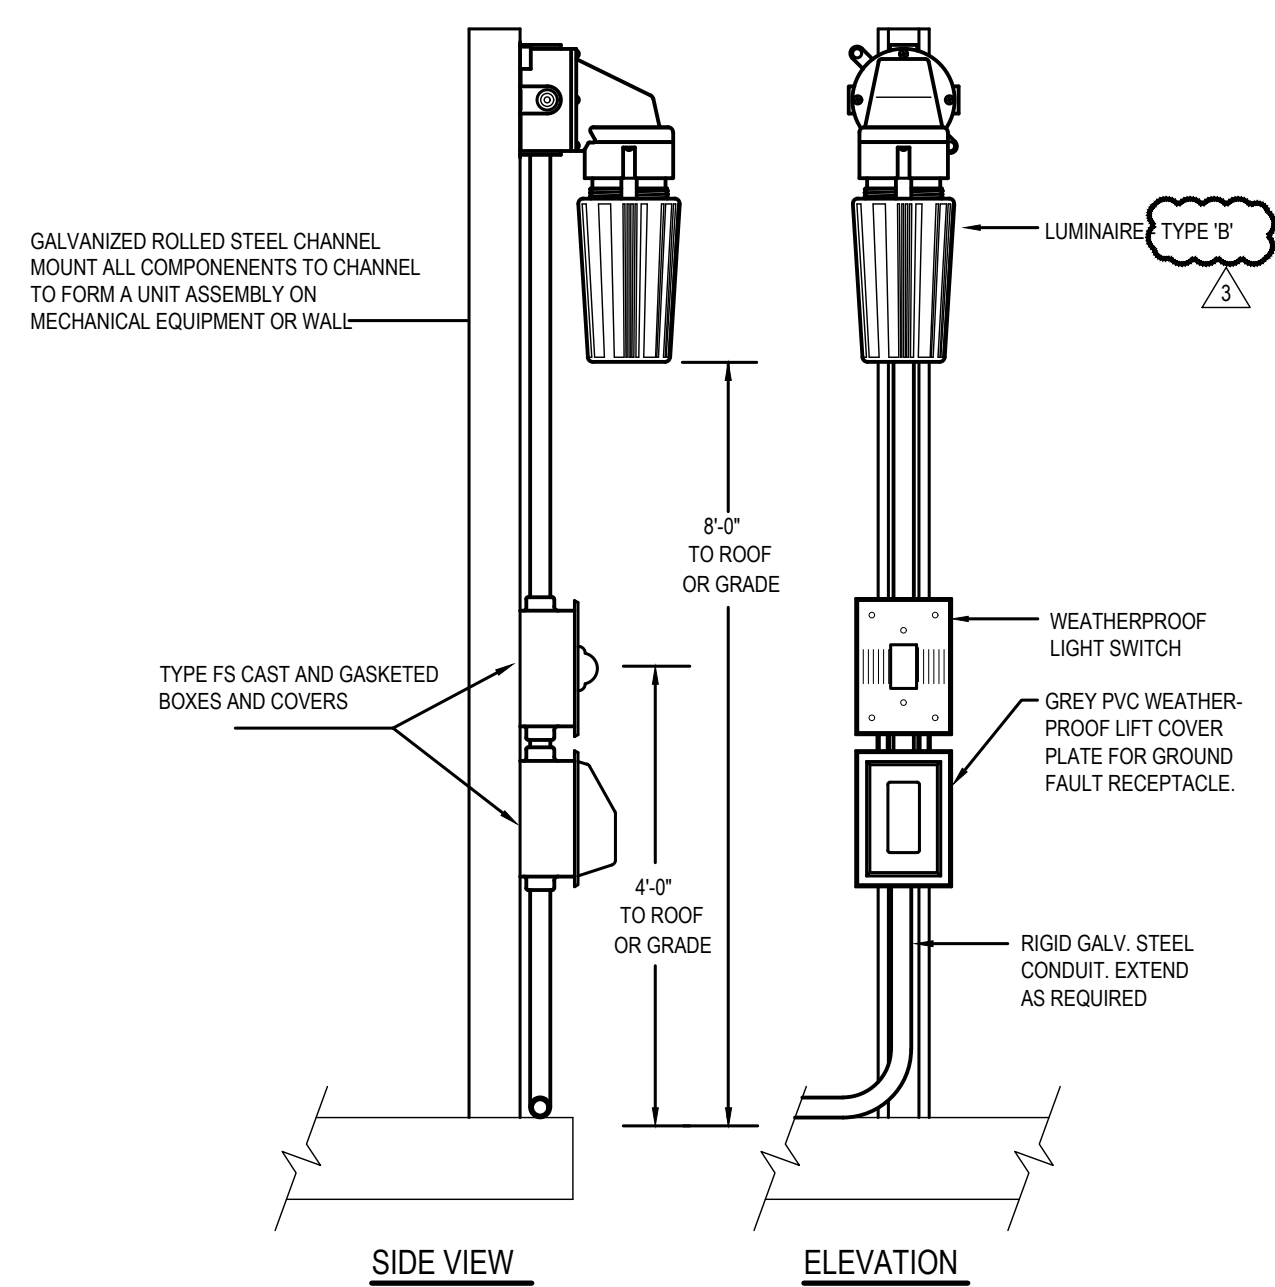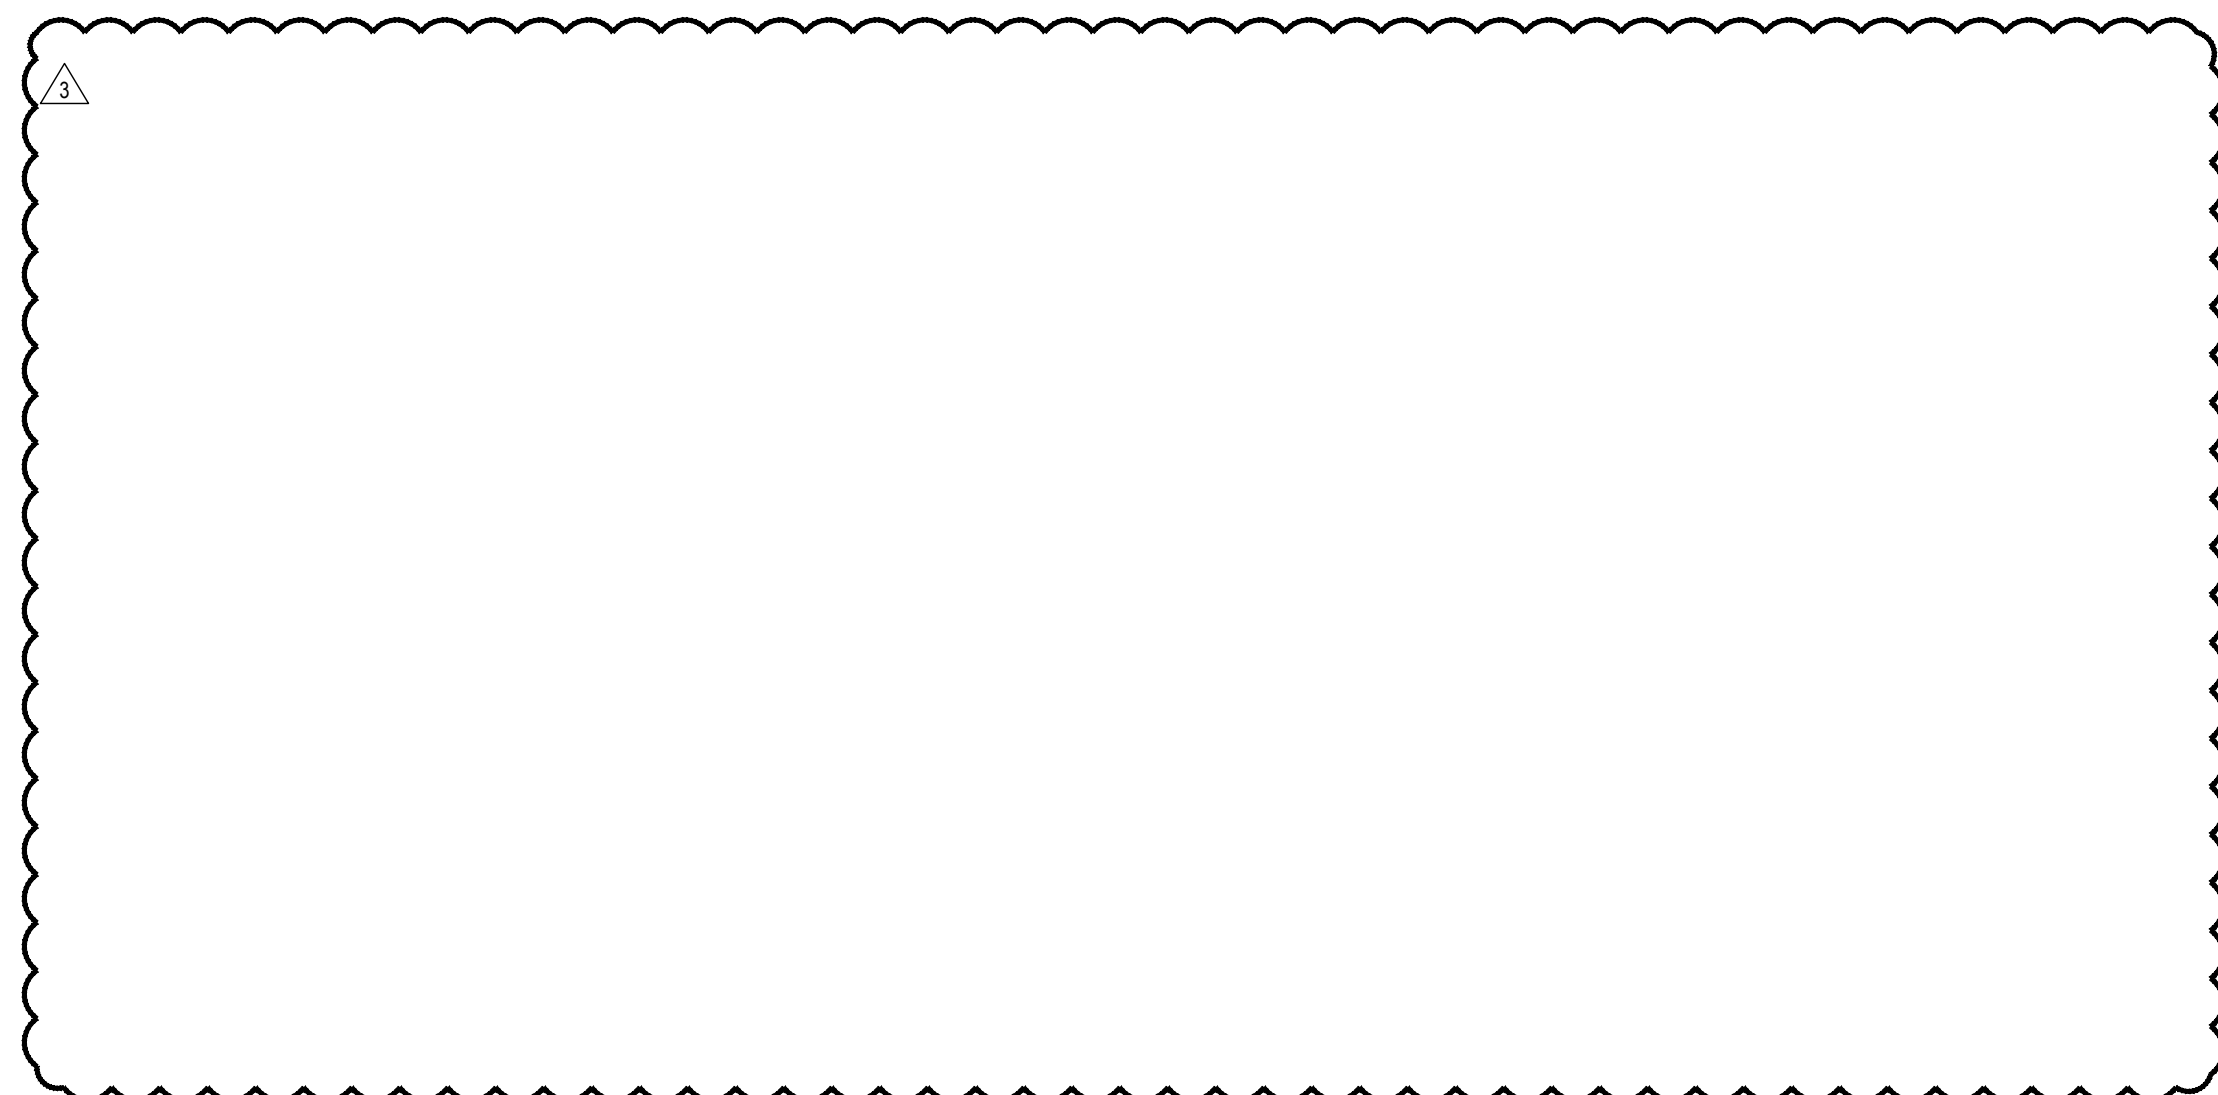

OUTDOOR EQUIPMENT LIGHT & RECEPTACLE DETAIL

[illegible]

PROJECT #:	140145.00
FILENAME:	
DRAWN:	WFW
CHECKED:	WFW
DATE:	07/25/11

DRAWING

E-19