

REVISIONS

CONSULTANT
CARTER, ROMANEK
Landscape Architects, Inc.
28720 Roadside Drive, Suite 100
Agoura Hills, California 91301
(310)477-3900



NORWALK LA MIRADA UNIFIED SCHOOL DISTRICT
**LA MIRADA HIGH SCHOOL NEW FOOTBALL
STADIUM PROJECT**
13520 ADELEA DRIVE, LA MIRADA, CA 90638

DSA # 03-120551

NAC
ARCHITECTURE

NAC NO. 161-19015
DATE 12-10-2020


DSA BACKCHECK
SUBMISSION

FIELD
CONSTRUCTION
PLAN

TF 2.2


NOTES

- ① SYNTHETIC TURF ①
- ② SDR 35 PVC STORM DRAIN PER C5.01
- ③ SDR 35 PERFORATED PVC PERIMETER COLLECTOR PIPE PER C5.01
- ④ 1" X 12" FLAT TURF DRAIN, ADS ADVANEDGE OR EQUAL
- ⑤ FIELD COMMUNICATIONS AND POWER BOX PER ELECTRICAL SITE PLAN

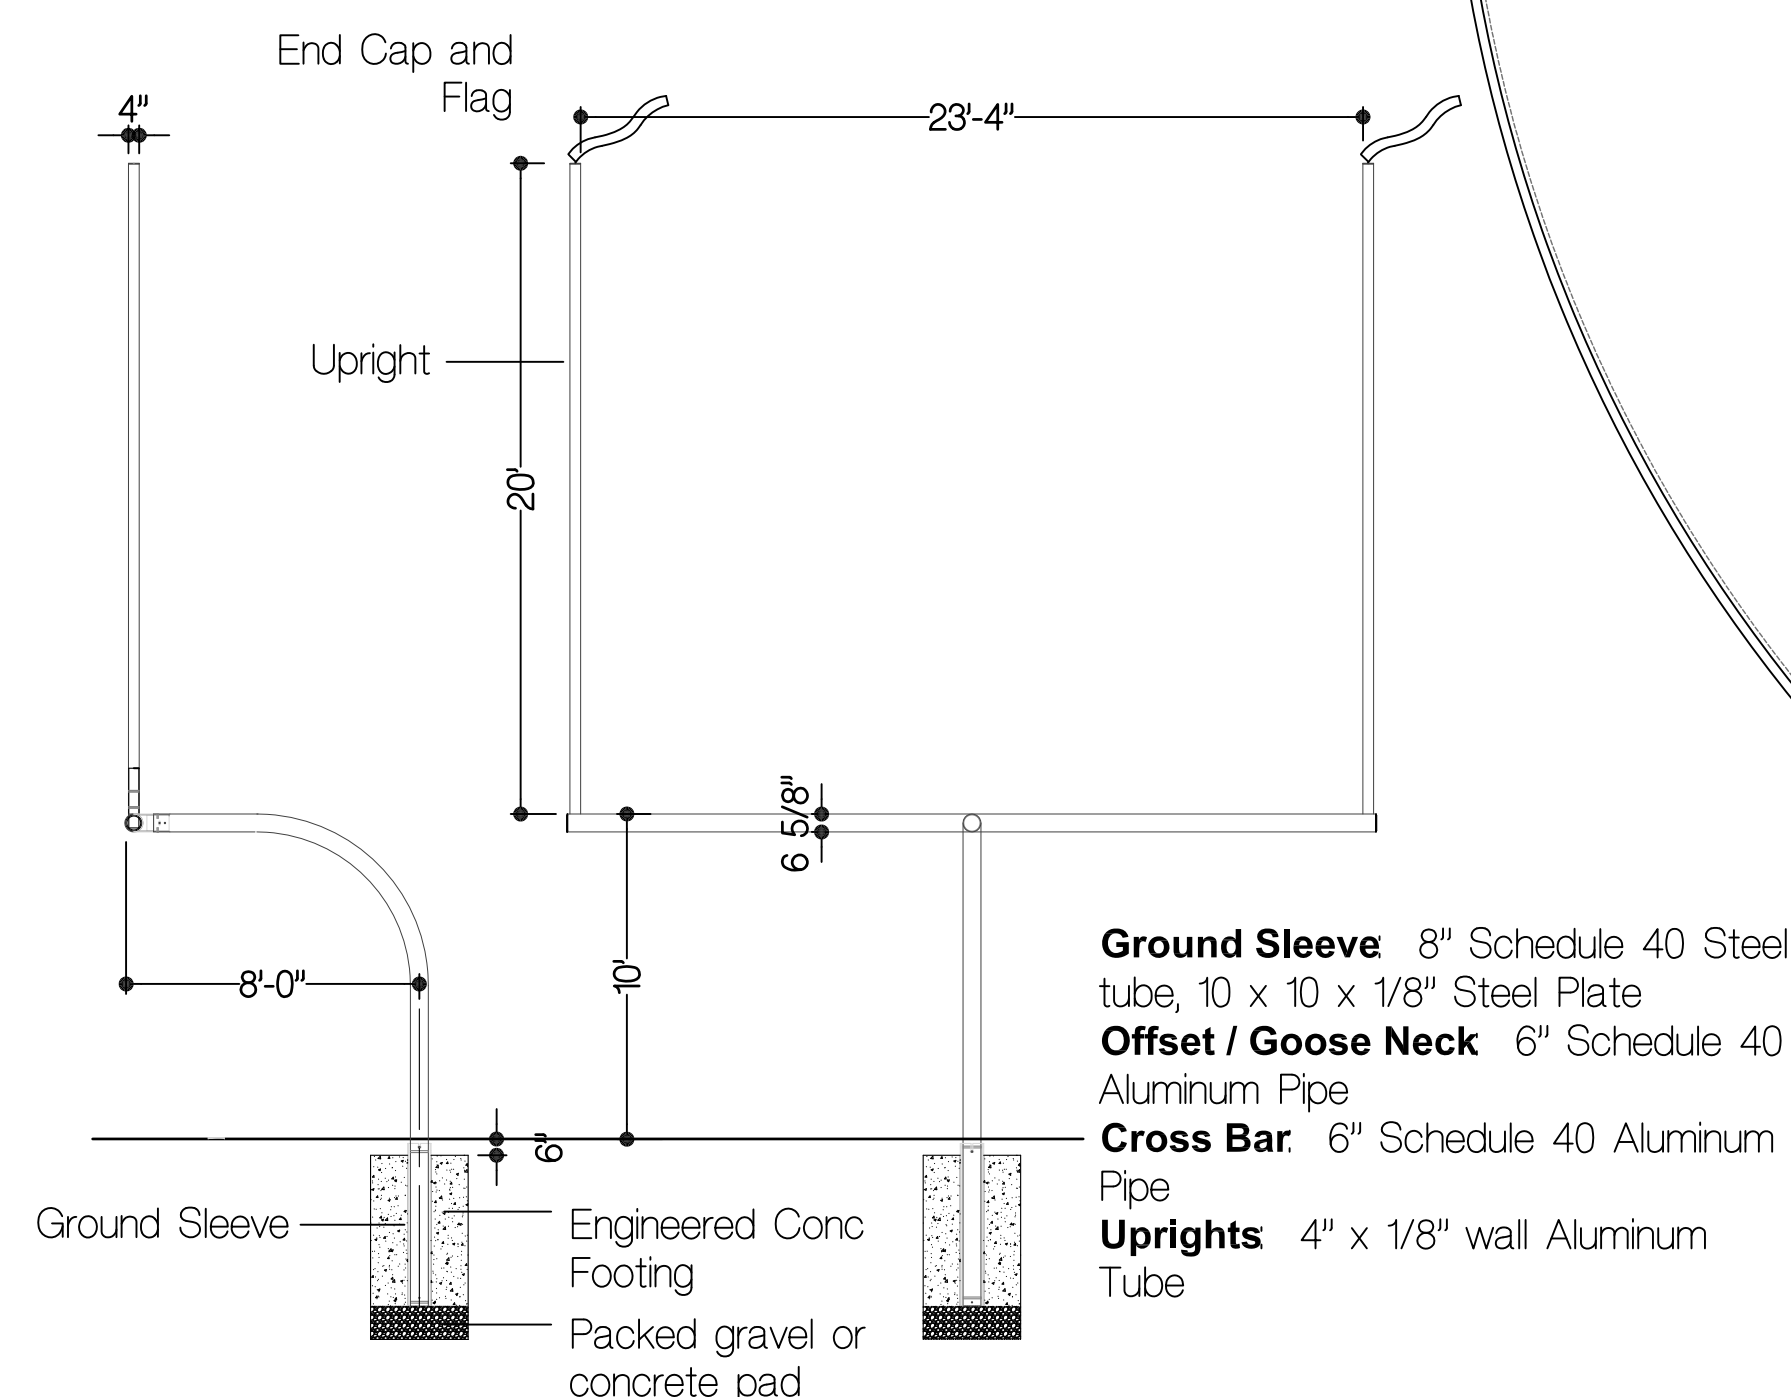


Ground Sleeve 8" Schedule 40 Steel tube, 10 x 10 x 1/8" Steel Plate
Offset / Goose Neck 6" Schedule 40 Aluminum Pipe
Cross Bar 6" Schedule 40 Aluminum Pipe
Uprights 4" x 1/8" wall Aluminum Tube

TRUE NORTH
PLAN NORTH
FIELD CONSTRUCTION PLAN
Scale: 1" = 20'-0"

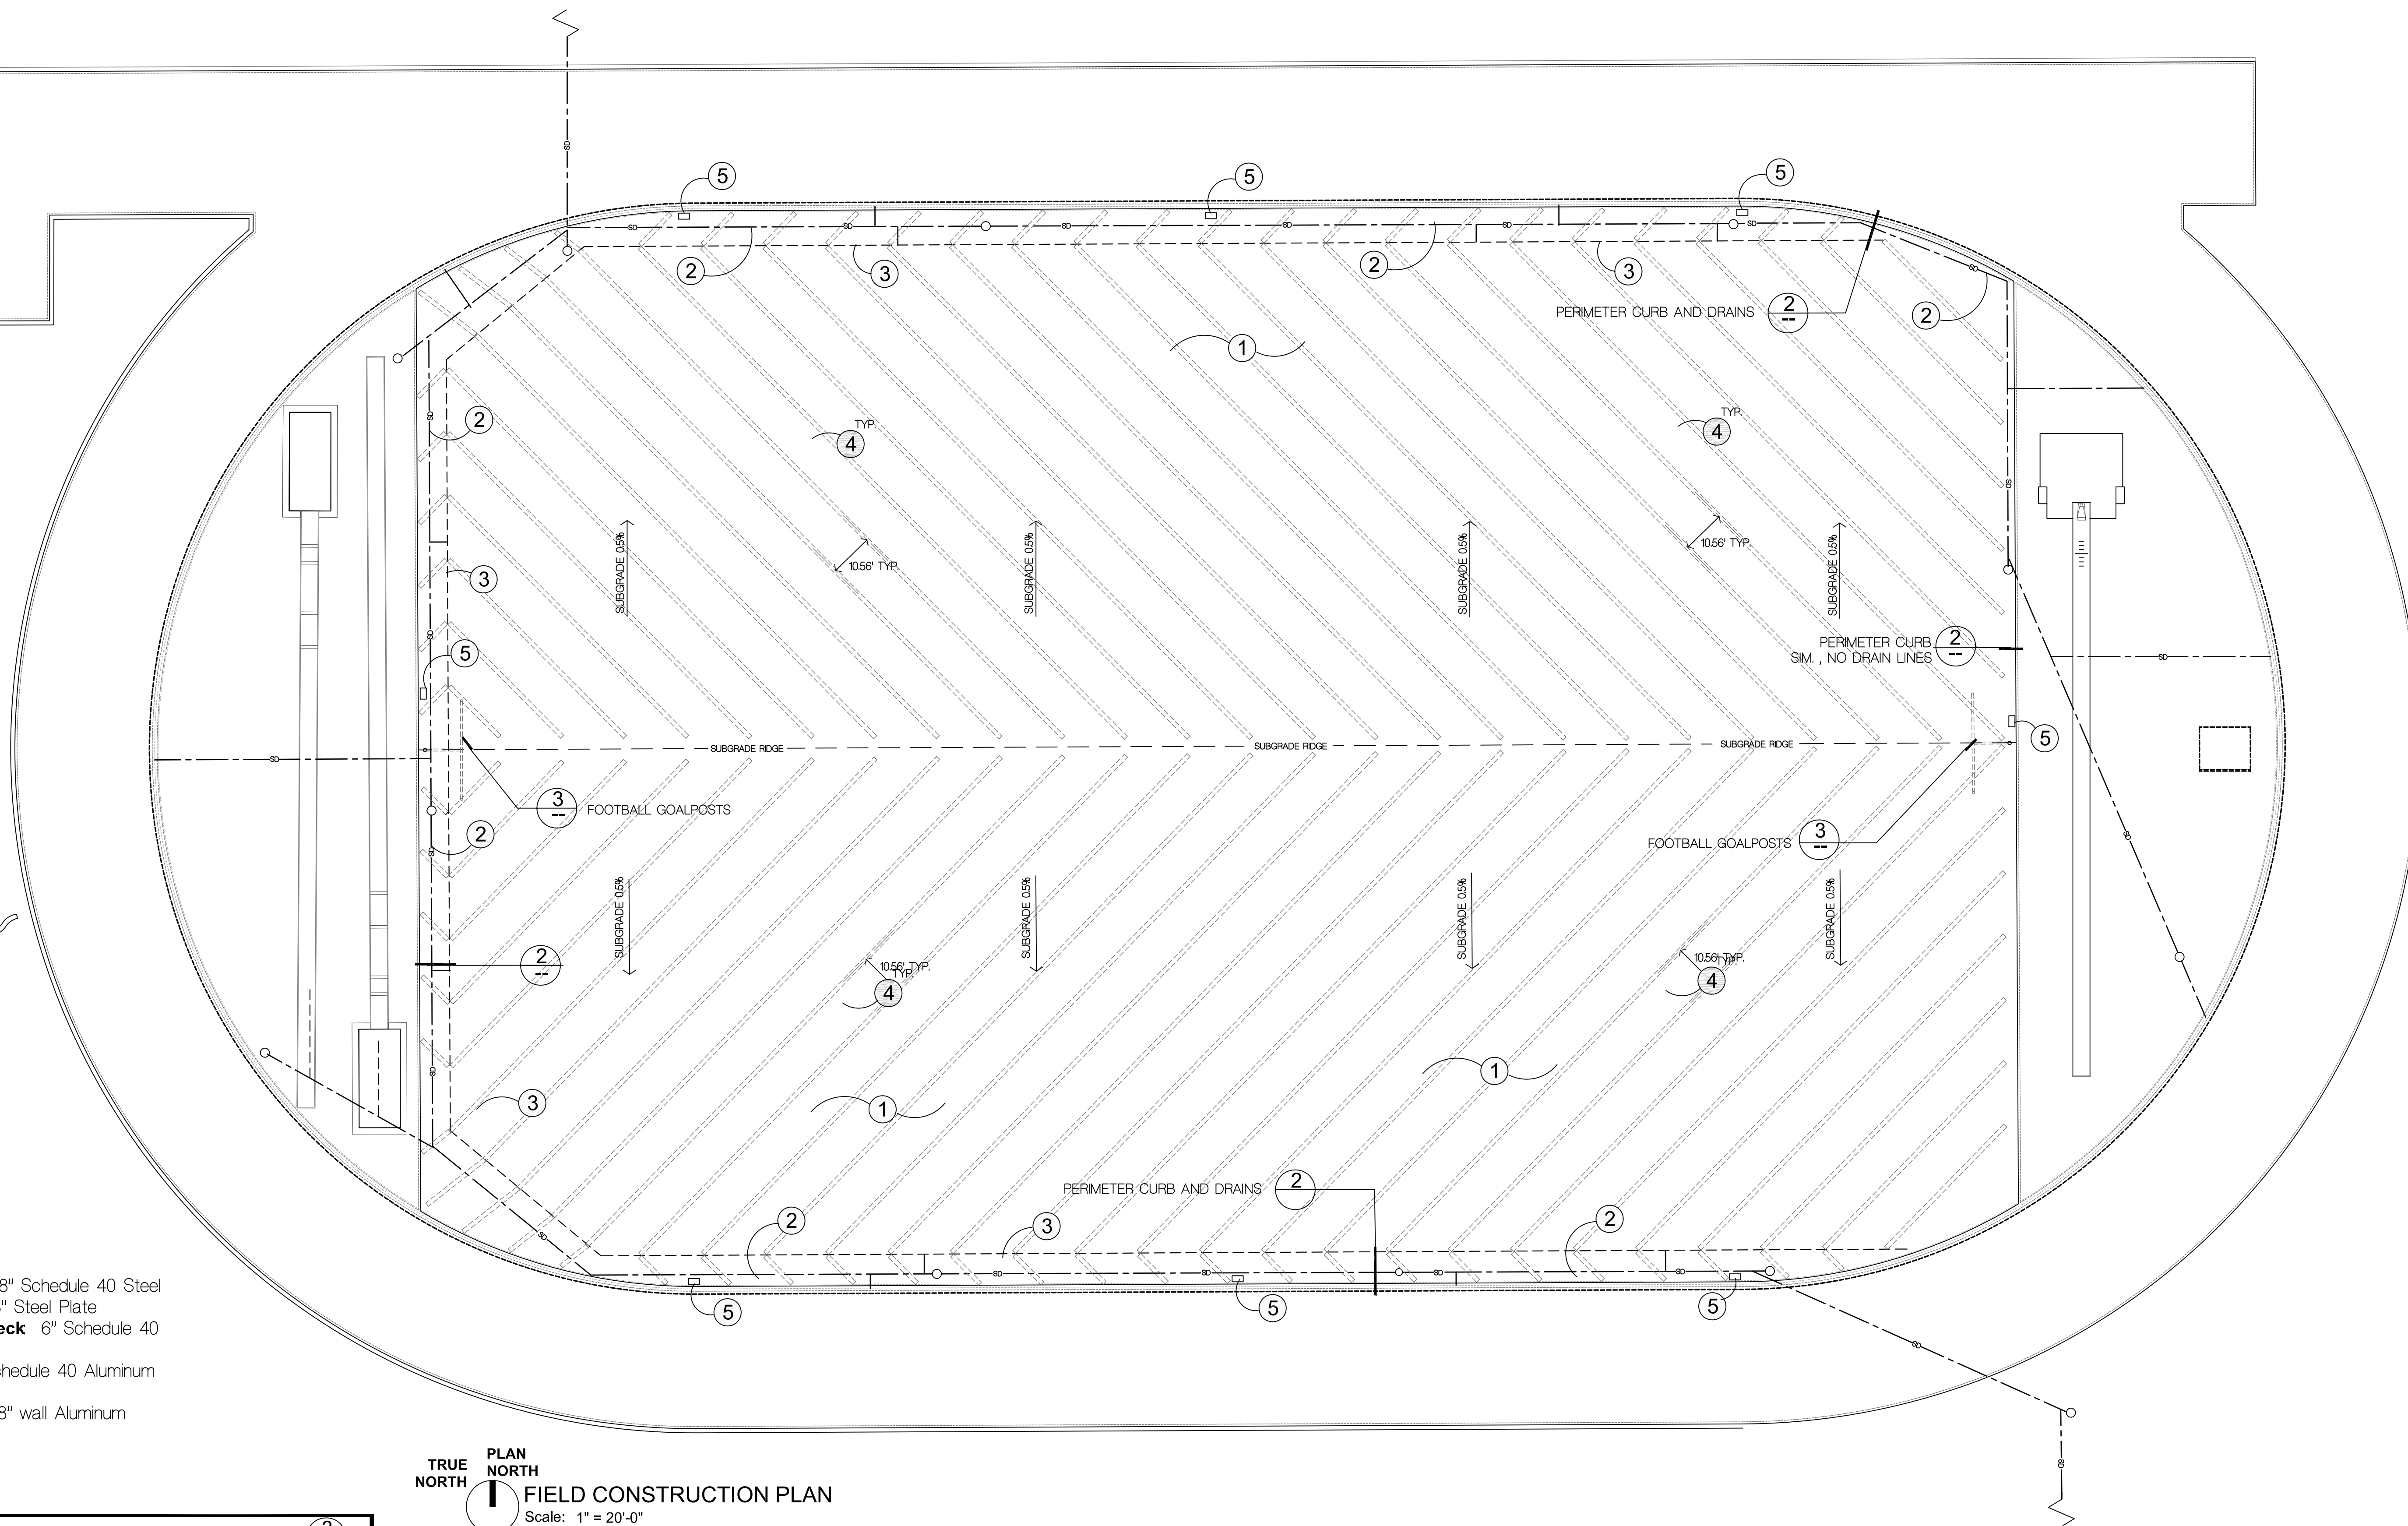


GOAL POST

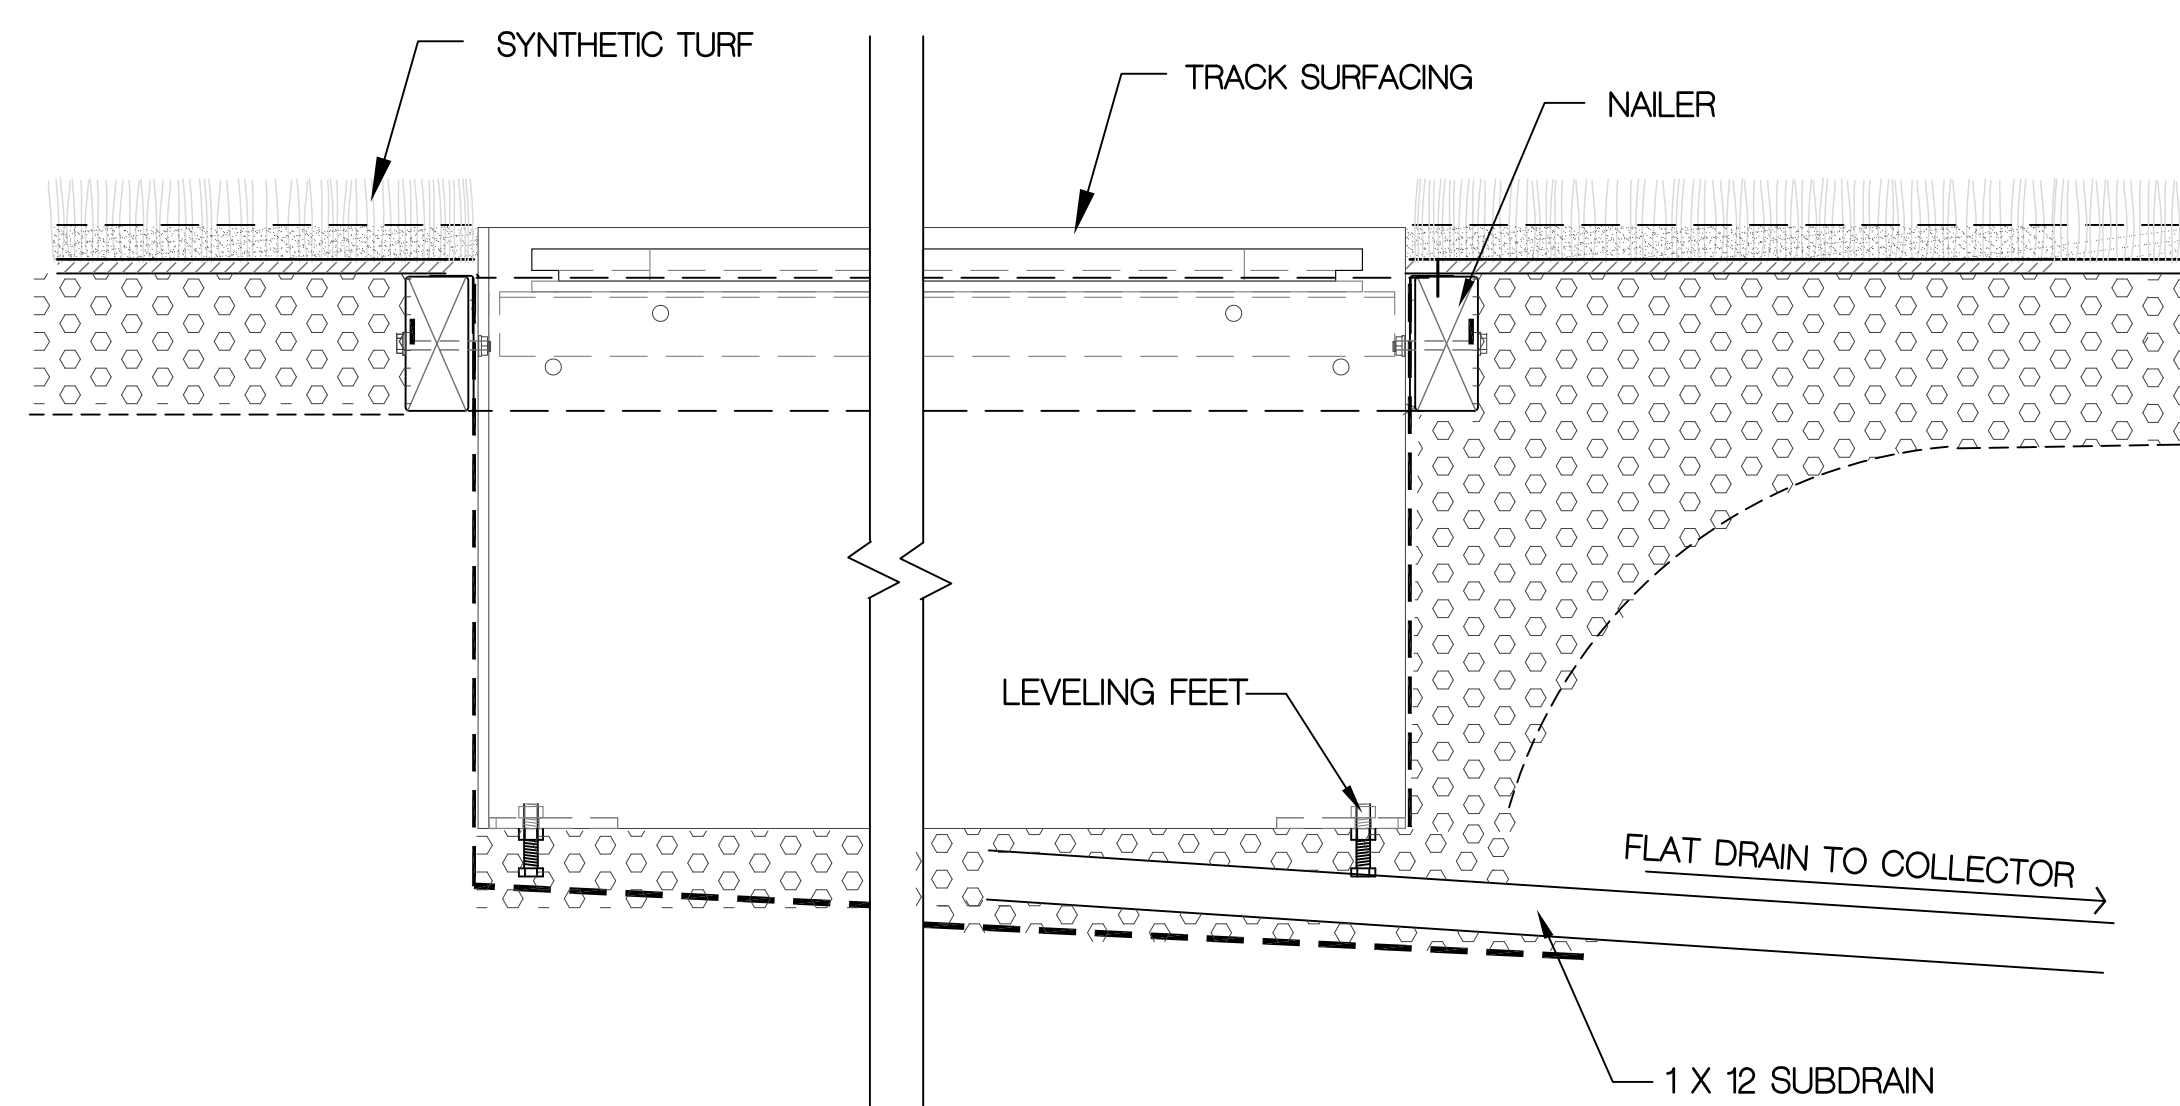

COMMUNICATION/POWER BOX

PERIMETER CURB AND DRAINS

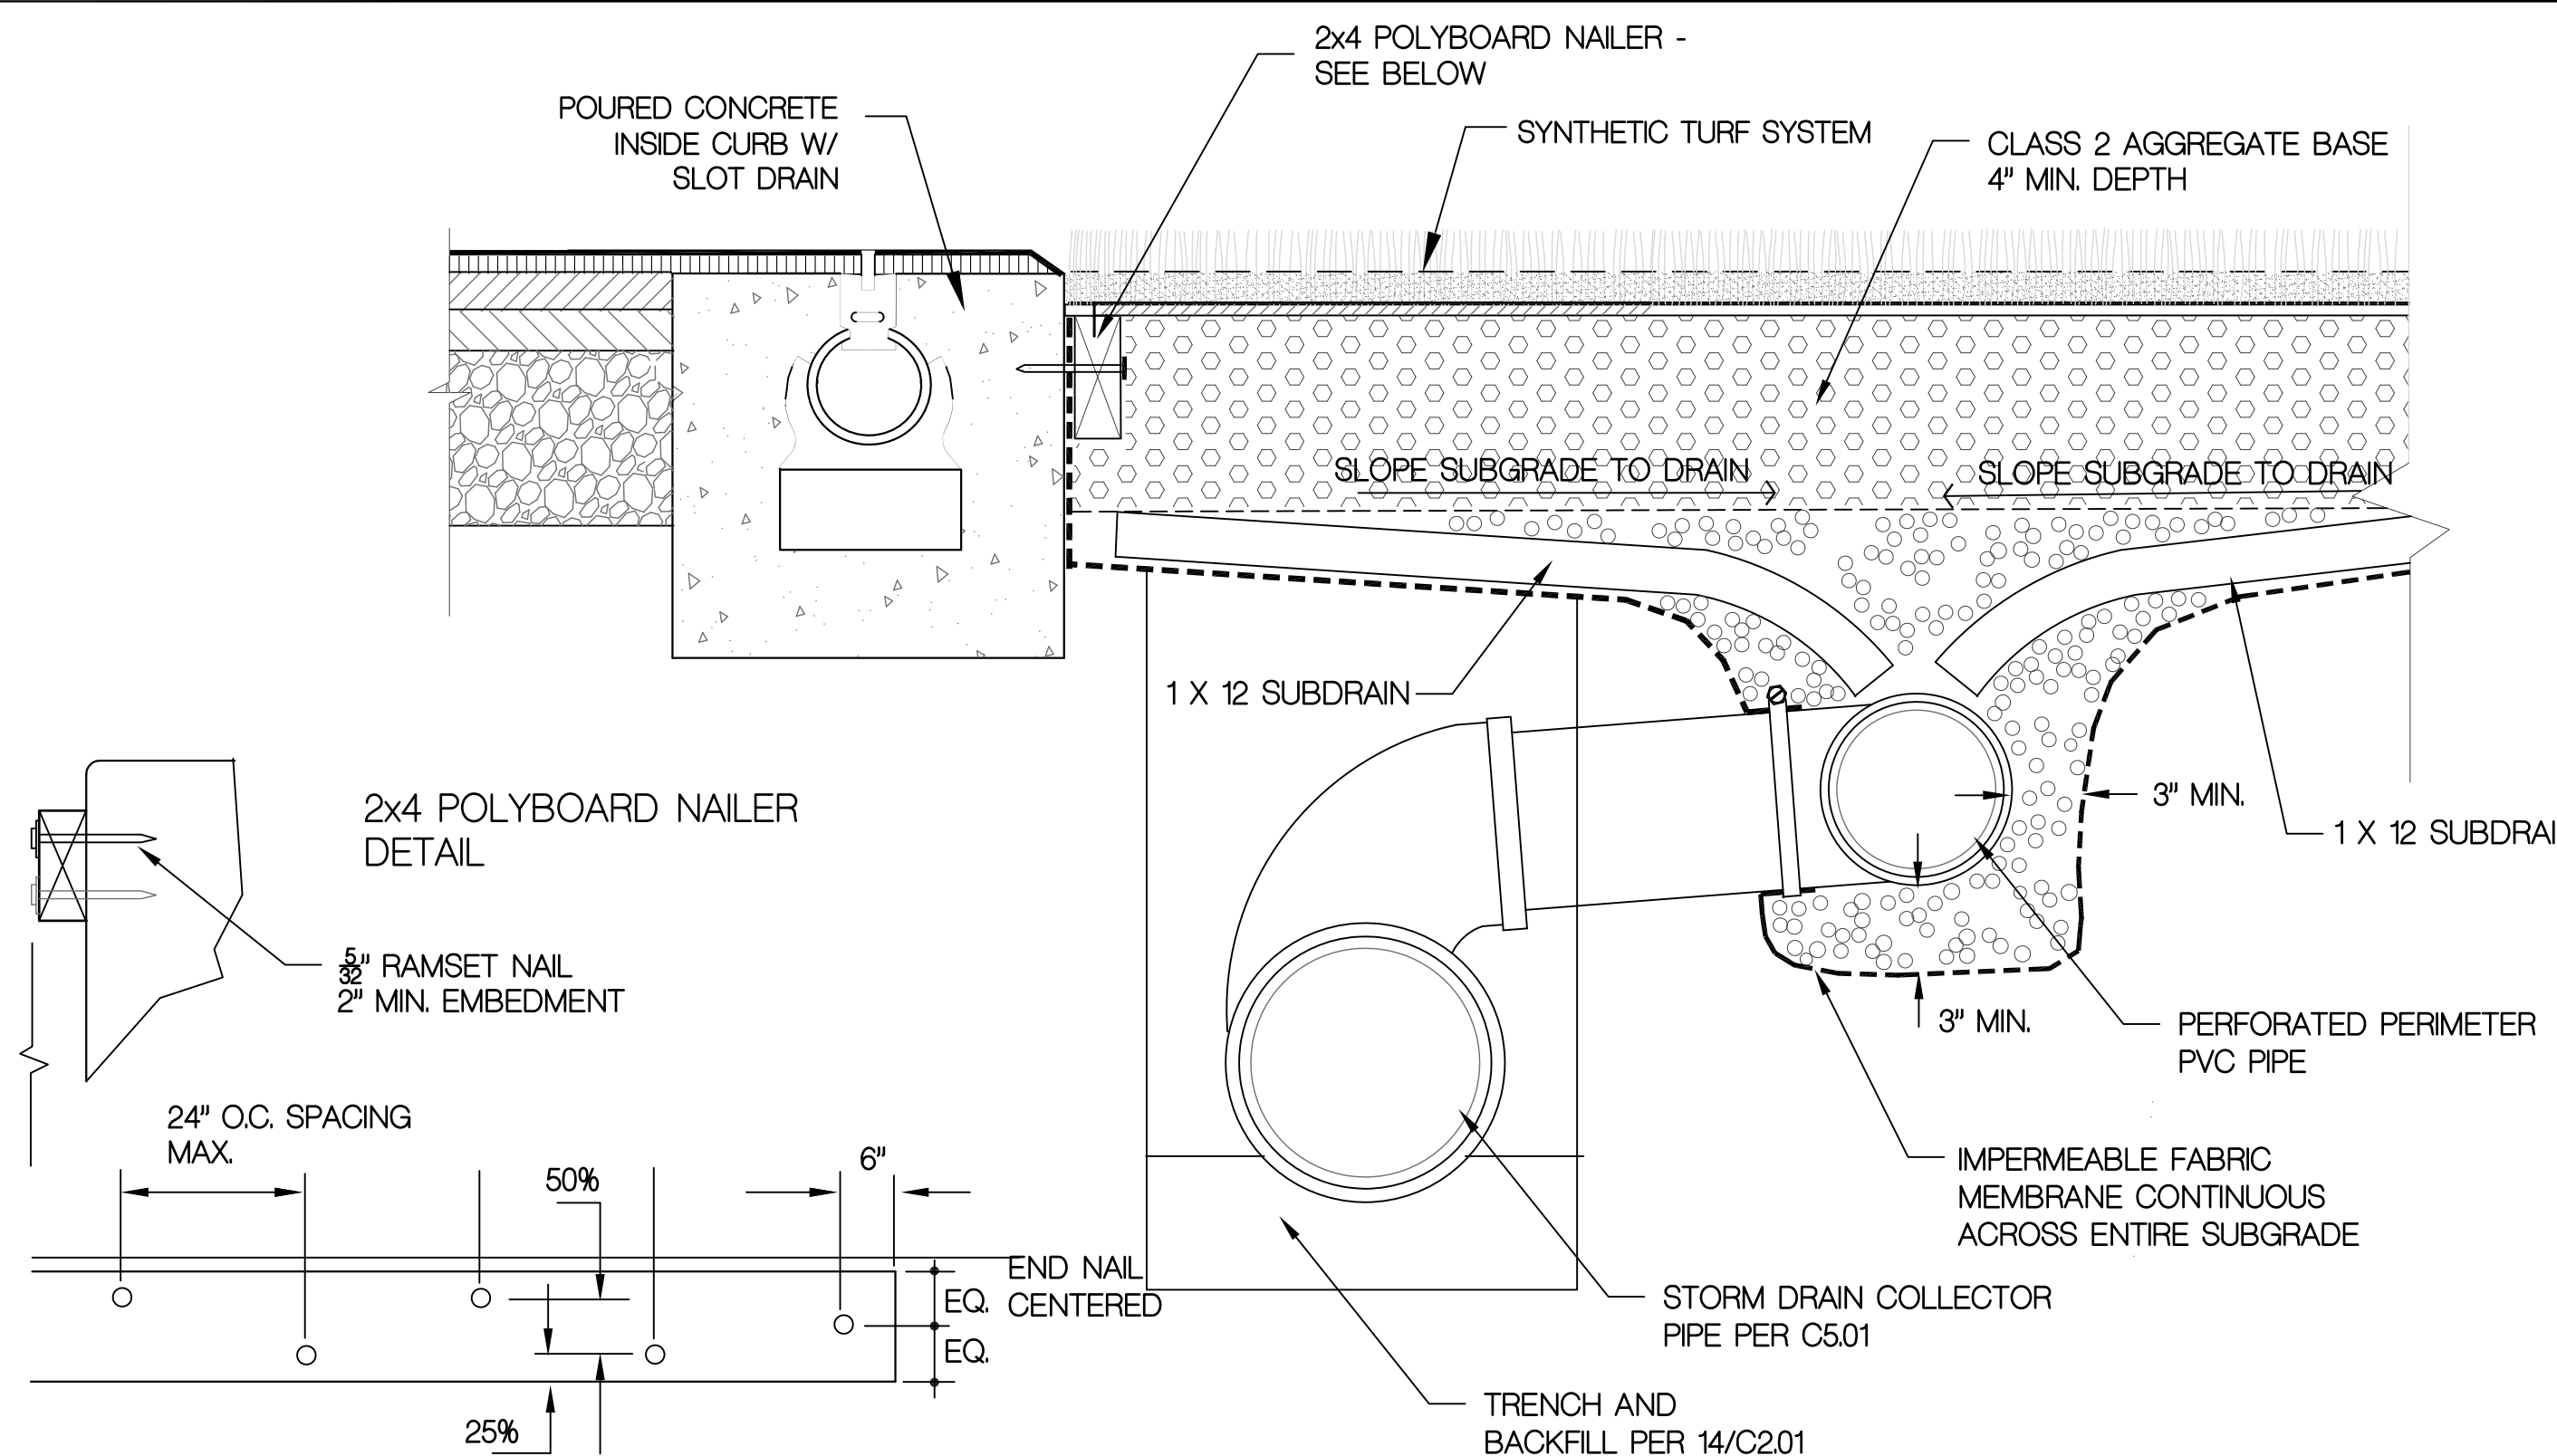

FIELD SECTION

