


2 BUILDING V - HOME FIELD HOUSE REFLECTED CEILING PLAN
Scale: 1/4" = 1'-0"

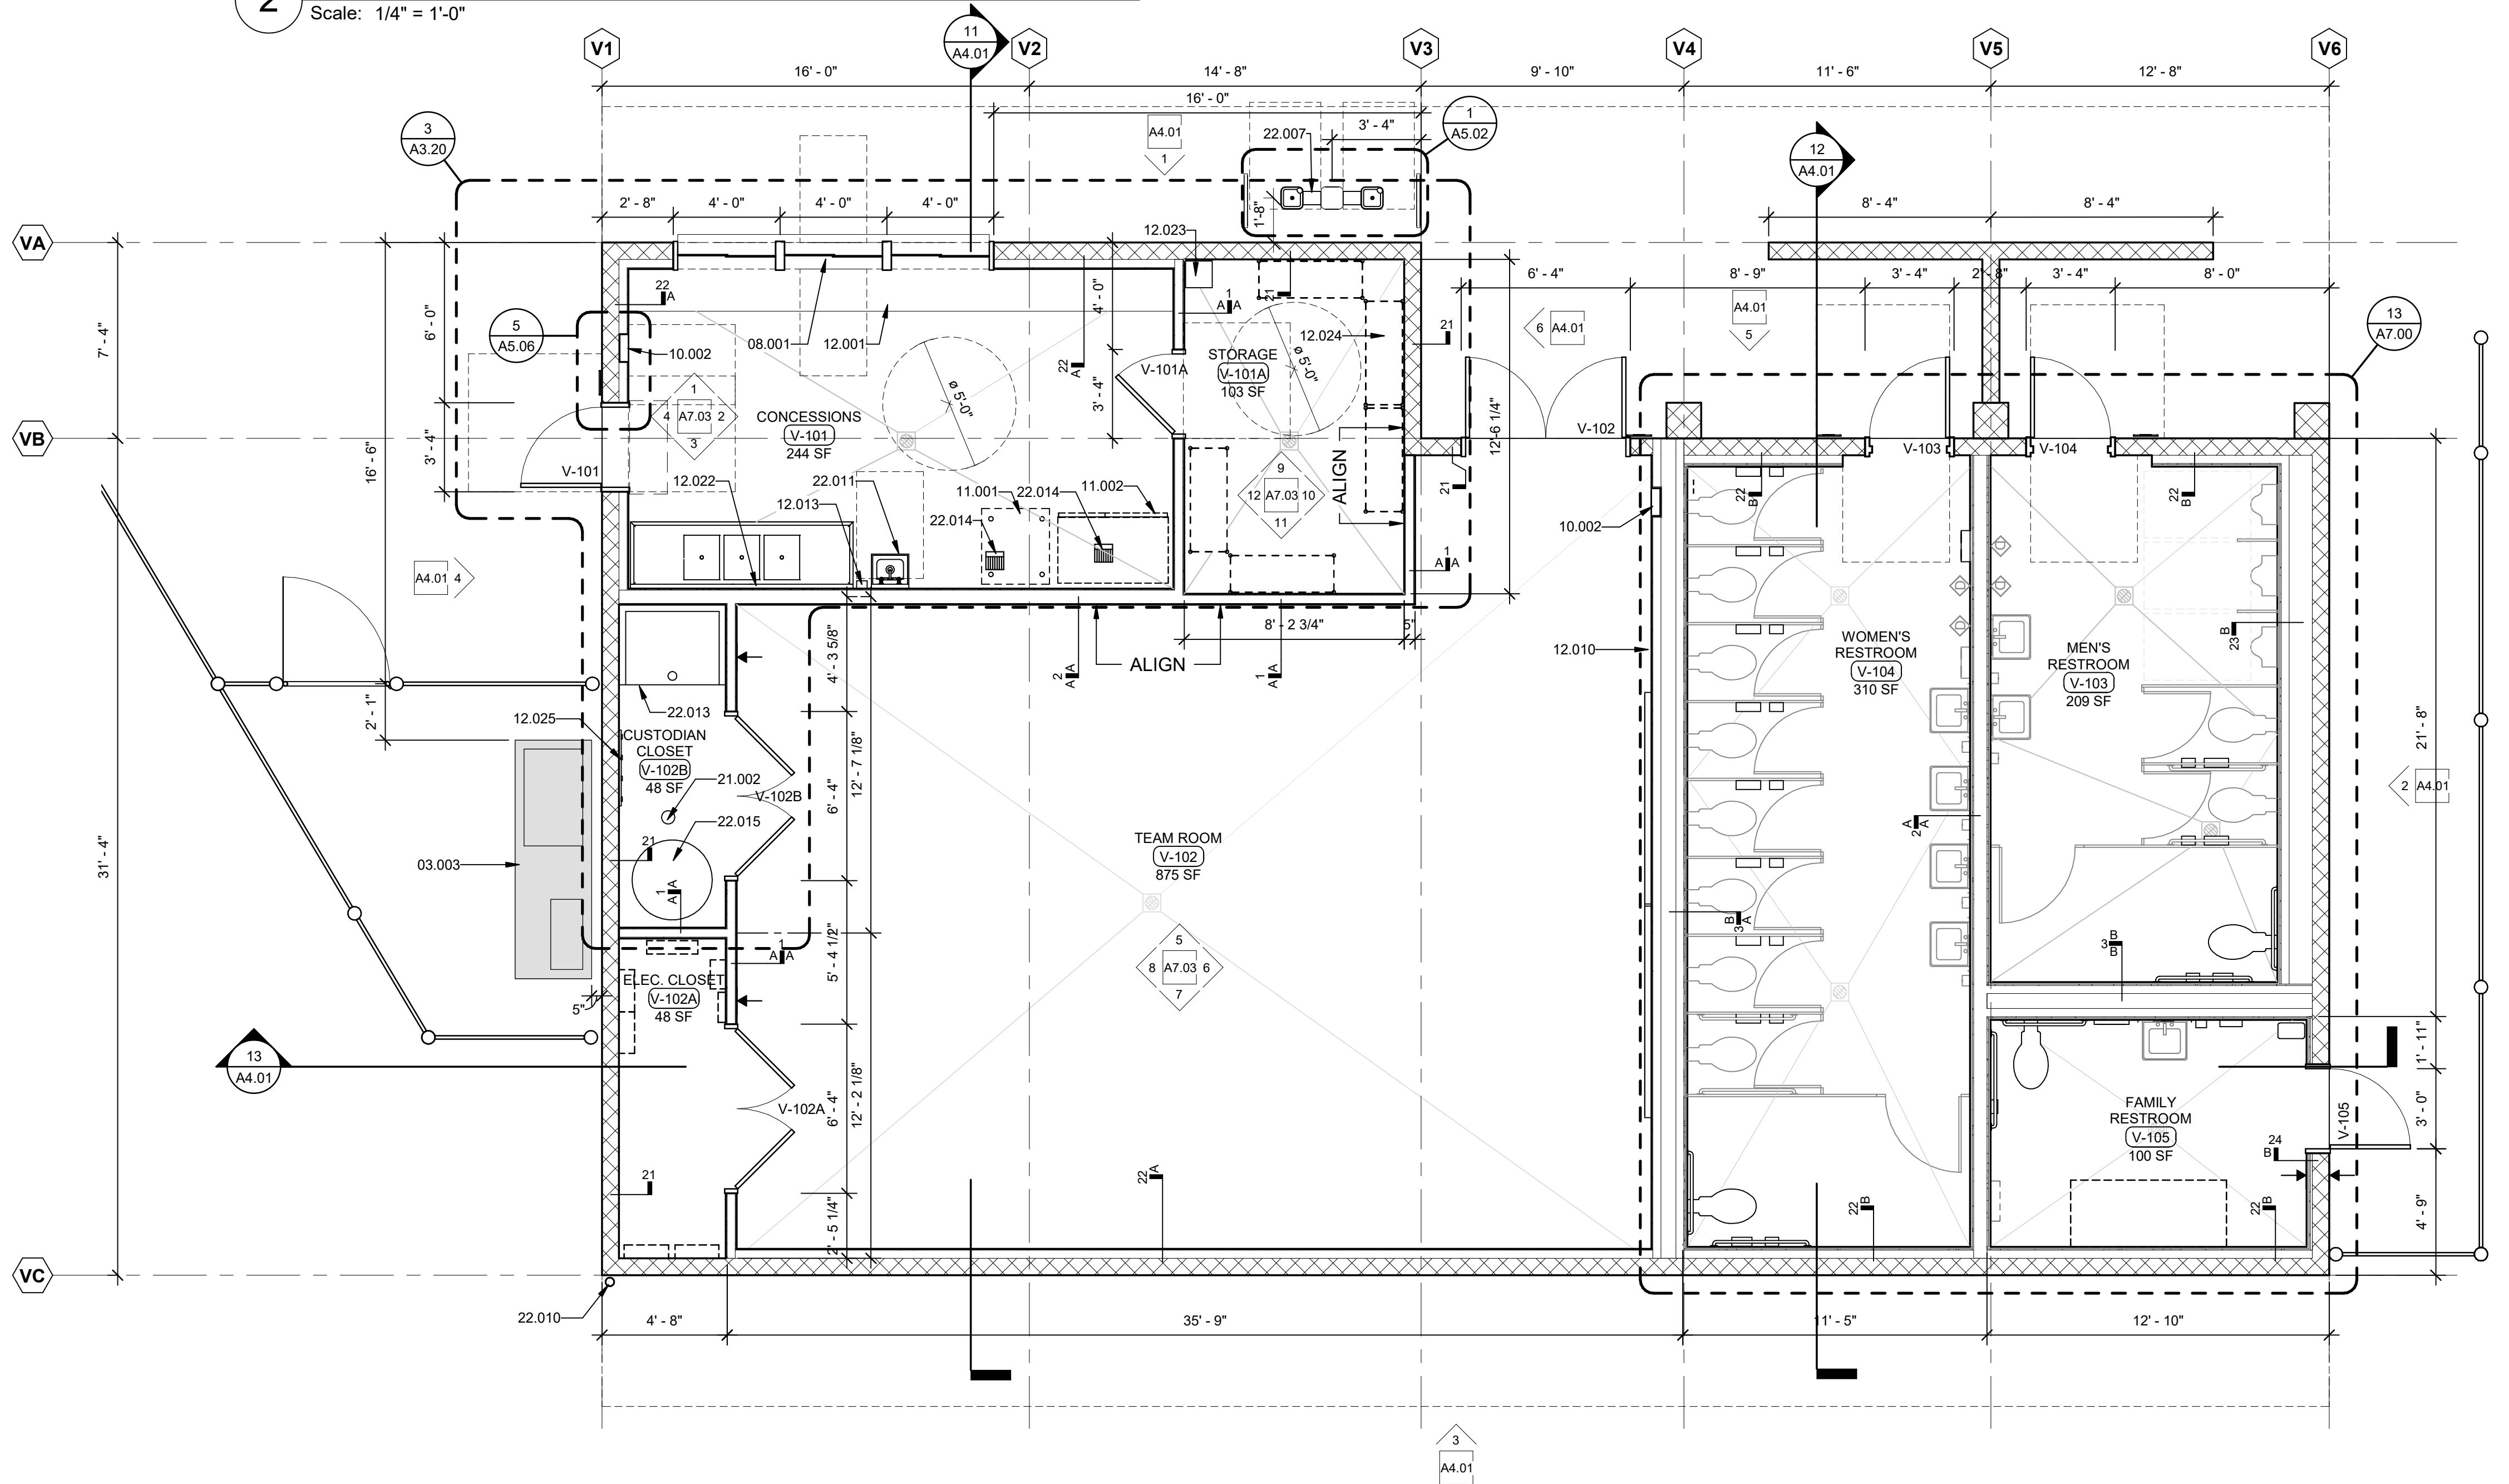

1 BUILDING V - HOME FIELD HOUSE FLOOR PLAN
Scale: 1/4" = 1'-0"

KEYNOTE

NOTE

03.003	ELEVATED CONCRETE PAD, SEE M8.01,SEE 1/S1.02
05.002	METAL DECK, PTD.
05.003	STEEL FRAMING, PTD.
08.001	WINDOW, SEE WINDOW SCHEDULE, TYP.
08.005	SKYLIGHT, SEE 8/A9.01 AND SCHEDULE ON A3.20
10.002	RECESSED FIRE EXTINGUISHER CABINET, SEE 3/A5.07
11.001	ICE MACHINE (OFC)
11.002	REFRIGERATOR (OFC)
12.001	STAINLESS STEEL COUNTERTOP, TYP.
12.010	16" MARKERBOARD, TYP.
12.013	LIQUID SOAP DISPENSER, TYP.
12.022	6" SPLASH GUARD
12.023	EMPLOYEE LOCKER
12.024	METAL SHELVING EQUIPMENT ON 6" HIGH LEGS
12.025	MOP RACK & CHEMICAL SHELF
21.001	FIRE SPRINKLERS, SEE FFP3.11 FOR LOCATION
21.002	FIRE RISER, SEE FFP3.10
22.007	HI-LO PEDESTAL DRINKING FOUNTAIN W/ WATER BOTTLE FILLER
22.010	3" METAL DOWNSPOUT 18GA, SEE P7.03 FOR SIZE
22.011	SINK, TYP.
22.013	MOP SINK
22.014	FLOOR SINK, TYP.
22.015	WATER HEATER, SEE PLUMBING DRAWINGS
26.004	6" LEG RECESSED DOWN LIGHT WITH DIE-FORMED HOUSING,SEE E0.03 & E7.01
26.005	PENDANT LIGHT FIXTURE, TYP., SEE A/E3.03

FLOOR PLAN LEGEND

NOTE: NOT ALL TYPES MAY BE USED

60" WHEELCHAIR TURNING CIRCLE

ACCESSIBLE LAVATORY

24" @ EXT. DOORS

DOOR ADA CLEARANCES

DRINKING FOUNTAIN

30x48 CLEAR SPACE

PH

1 HOUR FIRE BARRIER

LINE OF FLOOR/ ROOF ABOVE

WHEELCHAIR CLEAR FLOOR SPACE

SEMI-RECESSED FIRE EXTINGUISHER CABINET

SURFACE MOUNTED *FIRE EXTINGUISHER

BRACKET MOUNTED *FIRE EXTINGUISHER

*FIRE EXTINGUISHER & KNOX BOX TO BE LOCATED PER FIRE MARSHALL

O.F.O.I. FURNITURE, TYP.

FLOOR DRAIN @ CONC. FLOOR PER 14/A5.06

FLOOR DRAIN @ TILED FLOOR (DEPRESSED CONCRETE), SEE DETAIL 15/A5.05

DRAIN ELEVATION NOTED IS THE TOP OF DRAIN

CENTER DRAIN IN AREA INDICATED, U.N.O.

SLOPE FLOOR TO DRAIN 1/8" / 1'-0" MIN., 1/4" / 1'-0" MAX.

PANIC HARDWARE, SEE DOOR HARDWARE SCHEDULE

1 HOUR FIRE BARRIER

CEILING PLAN LEGEND

NOTE: NOT ALL TYPES MAY BE USED

SMOKE PARTITION, FULL HEIGHT TO DECK.

CEILING ACCESS PANEL, 30"x30" UNO. SEE 6/A5.09

CEILING HEIGHT (HEIGHTS INDICATED ARE RELATIVE TO 100'-0" FLOOR LEVEL).

VIDEO CAMERA

DAYLIGHT SENSOR

OCCUPANCY SENSOR

MOTION DETECTOR

ALARM SIREN

FIRE ALARM HORN

FIRE ALARM STROBE

LIGHT FIXTURES

SUSPENDED LIGHT FIXTURES

SUPPLY DIFFUSERS

RETURN AIR REGISTER OR EXHAUST FAN

EXIT LIGHT

SMOKE DETECTOR

HEAT DETECTOR

INTERCOM

PAGING SPEAKER

INFRARED DETECTOR

SPEAKER

FIRE PROTECTION SPRINKLER

EXHAUST FAN

CEILING TYPES

C-1 SUSPENDED 5/8 GYPSUM BOARD, PAINTED, SEE 1/A5.09

C-2 EXPOSED METAL DECK, PAINTED

GENERAL RCP NOTES

1. GENERALLY CENTER CEILING GRIDS IN EACH ROOM TO PROVIDE EQUALLY SIZED PANELS ON OPPOSITE WALLS. IF PLANS INDICATE A GRID ALIGNING WITH A COLUMN, WALL, SOFFIT, ETC, START GRID AT THE INDICATED SURFACE. AVOID PANELS LESS THAN 12" IN WIDTH.

2. SEE FINISH SCHEDULE FOR COLORS.

3. ALL GYP BD CEILING AND SOFFITS TO BE PAINTED.

4. ALL EXPOSED STEEL FRAMING AND DECK AT CEILINGS TO BE PAINTED.

5. EXCEPT AT STORAGE, MECHANICAL AND ELECTRICAL UTILITY ROOMS PAINT ALL EXPOSED DUCTWORK, PIPING AND CONDUITS.

6. CEILING HEIGHT TO BE MEASURED FROM FINISH FLOOR LEVEL OF THE ROOM OR THE AREA WHERE CEILING IS IN. CEILING HEIGHT ABOVE RAMP TO BE MEASURED FROM BOTTOM OF LOWEST LEVEL LANDING OF RAMP.

IDENTIFICATION STAMP
DIV. OF THE STATE ARCHITECT
APP: 03-120551 INC.
REVIEWED FOR
SS ☒ FLS ☒ ACS ☒
DATE: 01/11/2021

REVISIONS

1 DSA_V2 Date 1

NORWALK LA MIRADA UNIFIED SCHOOL DISTRICT
LA MIRADA HIGH SCHOOL NEW FOOTBALL
STADIUM PROJECT
13520 ADELEA DRIVE, LA MIRADA, CA 90638

DSA # 03-120551

NAC
ARCHITECTURE

NAC NO. 161-19015
DATE 12/10/2020

DSA BACKCHECK
SUBMISSION

BUILDING V - PLAN / RCP

A3.10

12/10/2020 4:30:12 PM D:\Revit\161-19015-LaMiradaArchitect\FIELD_ARCH\gmaAFT39.rvt

© 2020 NAC INC.