

- SHEET NOTES
- ①

REFRIGERANT LINES UTR.
- ②

1/4" AND 3/8" REFRIGERANT LINES. OFFSET AS HIGH AS POSSIBLE.
- ③

SEE DETAIL ON 12/M11.01 FOR HP ANCHORAGE ON PRESS BOX ROOF.
- ④

REFRIGERANT LINES UP FROM PRESS BOX.
- ⑤

PROVIDE NEW SCHNEIDER ELECTRIC SE 8000 SERIES THERMOSTAT. PROVIDE OVERRIDE BUTTON ON THERMOSTAT TO ALLOW "OFF--SCHEDULE" USE.

IDENTIFICATION STAMP
DIV. OF THE STATE ARCHITECT

APP: 03-120551 INC:

REVIEWED FOR

SS ☒ FLS ☒ ACS ☒

DATE: 01/11/2021

REVISIONS



1909B.M00

TURPIN & RATTAN


ENGINEERING, INC.

CONSULTING ENGINEERS

1455 ROCKAWAY DRIVE, SUITE 200


MONTROSE, CA 91026-1888

818 / 249 / 0444 FAX 818 / 1487

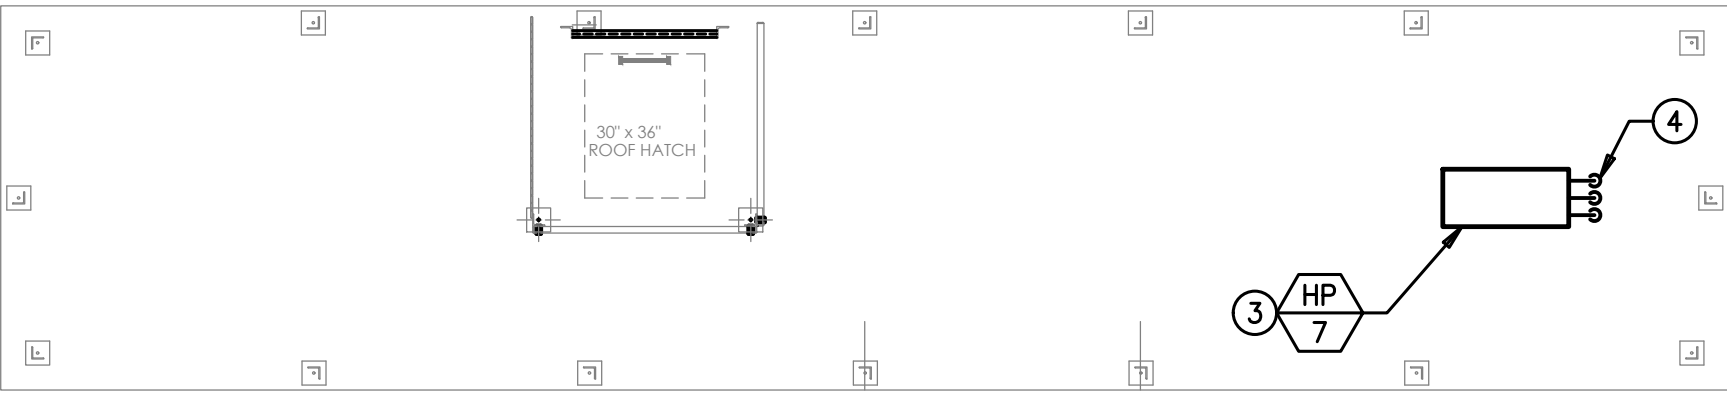

PRESS BOX ROOF PLAN - MECHANICAL

SCALE: 1/4" = 1'-0"

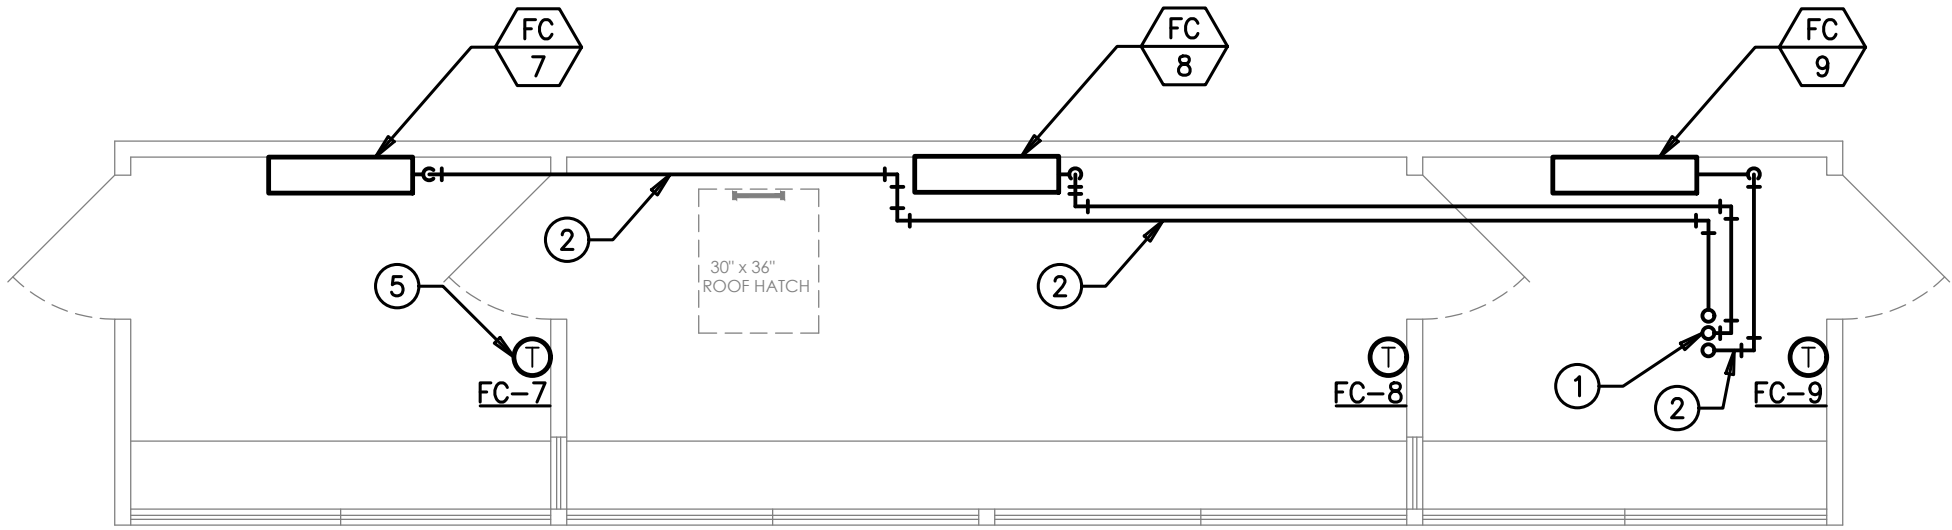

PRESS BOX FLOOR PLAN - MECHANICAL

SCALE: 1/4" = 1'-0"



NORWALK LA MIRADA UNIFIED SCHOOL DISTRICT
LA MIRADA HIGH SCHOOL NEW FOOTBALL
STADIUM PROJECT
13520 ADELEFA DRIVE, LA MIRADA, CA 90638

DSA # 03-120551

NAC
ARCHITECTURE

NAC NO. 161-19015
DATE 12/10/2020

DSA BACKCHECK
SUBMISSION

FLOOR PLANS
PRESSBOX -
MECHANICAL

M10.01