

NUMBERED NOTES


① 6"Ø EXHAUST DUCT UTR, TERMINATE 6"Ø EXHAUST AIR DUCT WITH ROOF JACK.

IDENTIFICATION STAMP
DIV. OF THE STATE ARCHITECT
APP: 03-120551 INC:
REVIEWED FOR
SS ☒ FLS ☒ ACS ☒
DATE: 01/11/2021

REVISIONS



1909B.M00
TURPIN & RATTAN
ENGINEERING, INC.
CONSULTING ENGINEERS
1455 ROCKAWAY AVENUE, SUITE 300
MONTROSE, CA 91020-1888
818 / 249 / 0444 FAX 818 / 1487

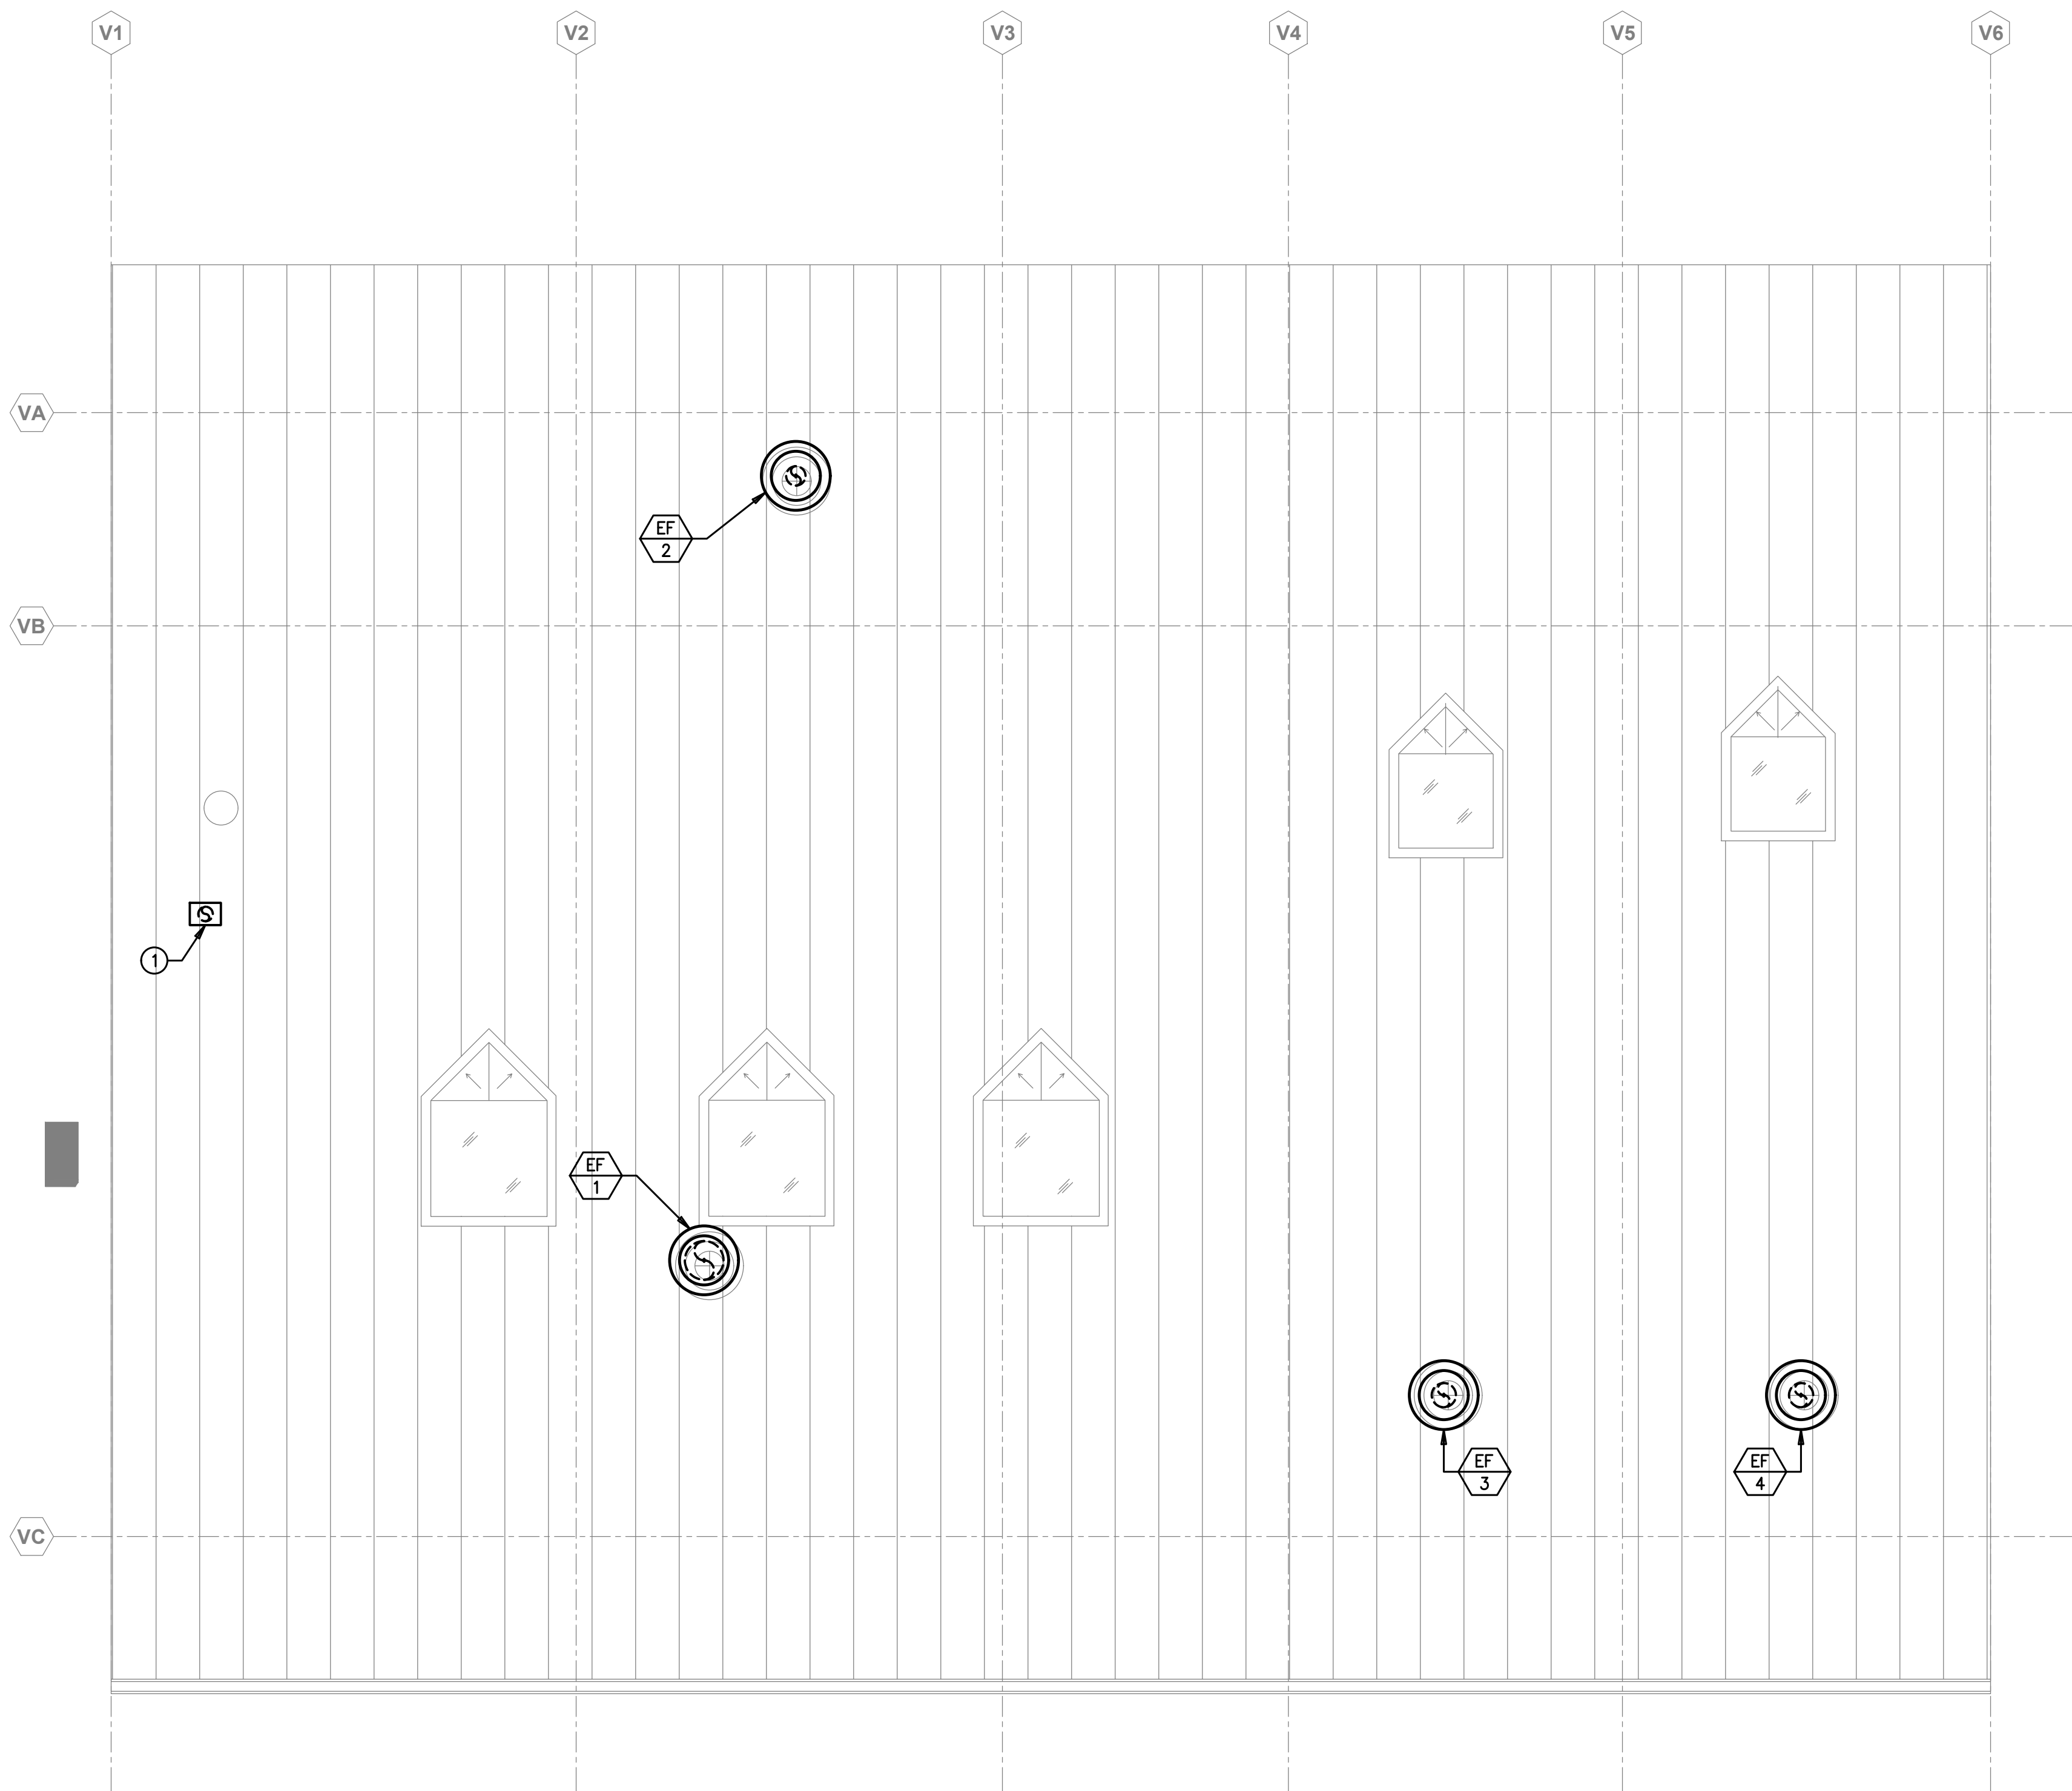

BUILDING "V" ROOF PLAN - MECHANICAL
SCALE: 1/4" = 1'-0"



NORWALK LA MIRADA UNIFIED SCHOOL DISTRICT
LA MIRADA HIGH SCHOOL NEW FOOTBALL
STADIUM PROJECT
13520 ADELFA DRIVE, LA MIRADA, CA 90638

DSA # 03-120551

NAC
ARCHITECTURE

NAC NO. 161-19015
DATE 12/10/2020

DSA BACKCHECK
SUBMISSION

ROOF PLANS
BUILDING "V" -
MECHANICAL

M7.03