

SHEET NOTES

1

3" ROOF DRAIN DN.

2

3" ROOF DRAIN DN FROM ROOF. RUN DN. BELOW GRADE.

3

PROVIDE SPLASH BLOCK FOR 3" ROOF DRAIN TERMINATION..

IDENTIFICATION STAMP

DIV. OF THE STATE ARCHITECT

APP: 03-120551 INC:

REVIEWED FOR

SS ☒ FLS ☒ ACS ☒

DATE: 01/11/2021

REVISIONS



1909B.M00

TURPIN & RATTAN


ENGINEERING, INC.

CONSULTING ENGINEERS


14000 JACARANDA DRIVE, SUITE 300

MONTROSE, CA 91020-1888

818 / 249 / 0444 FAX 818 / 1487

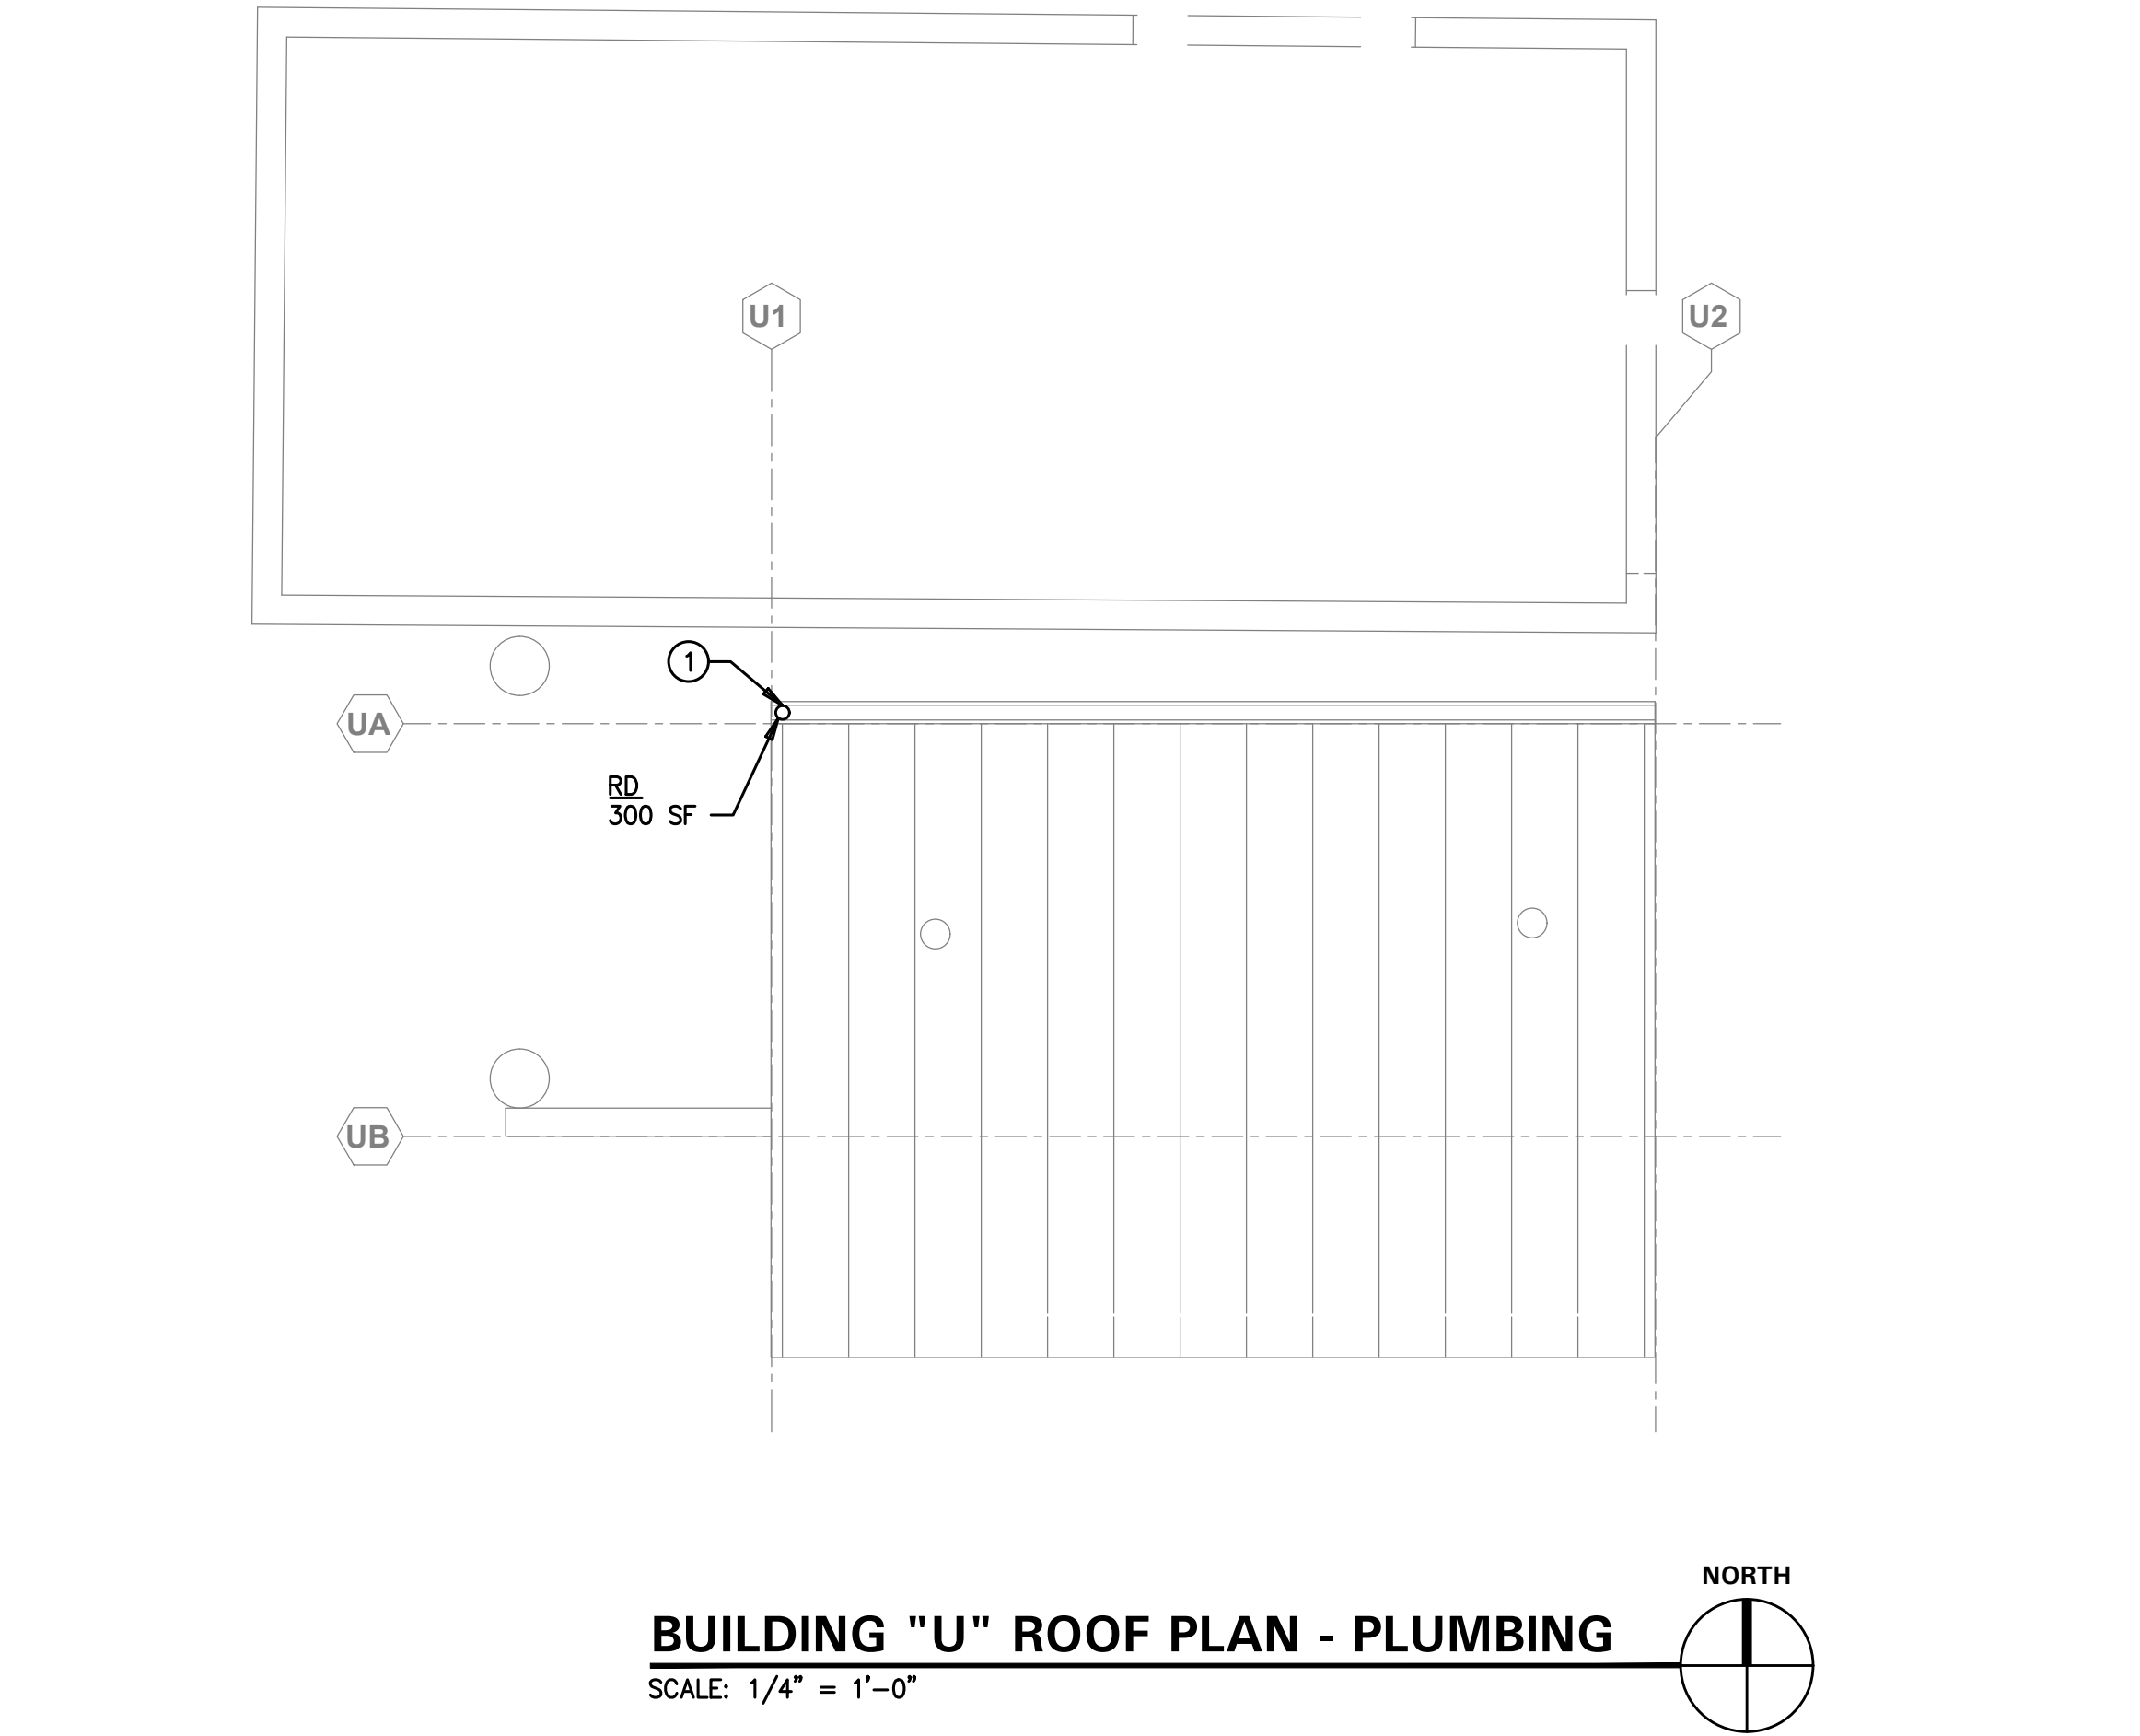

BUILDING "U" ROOF PLAN - PLUMBING
SCALE: 1/4" = 1'-0"

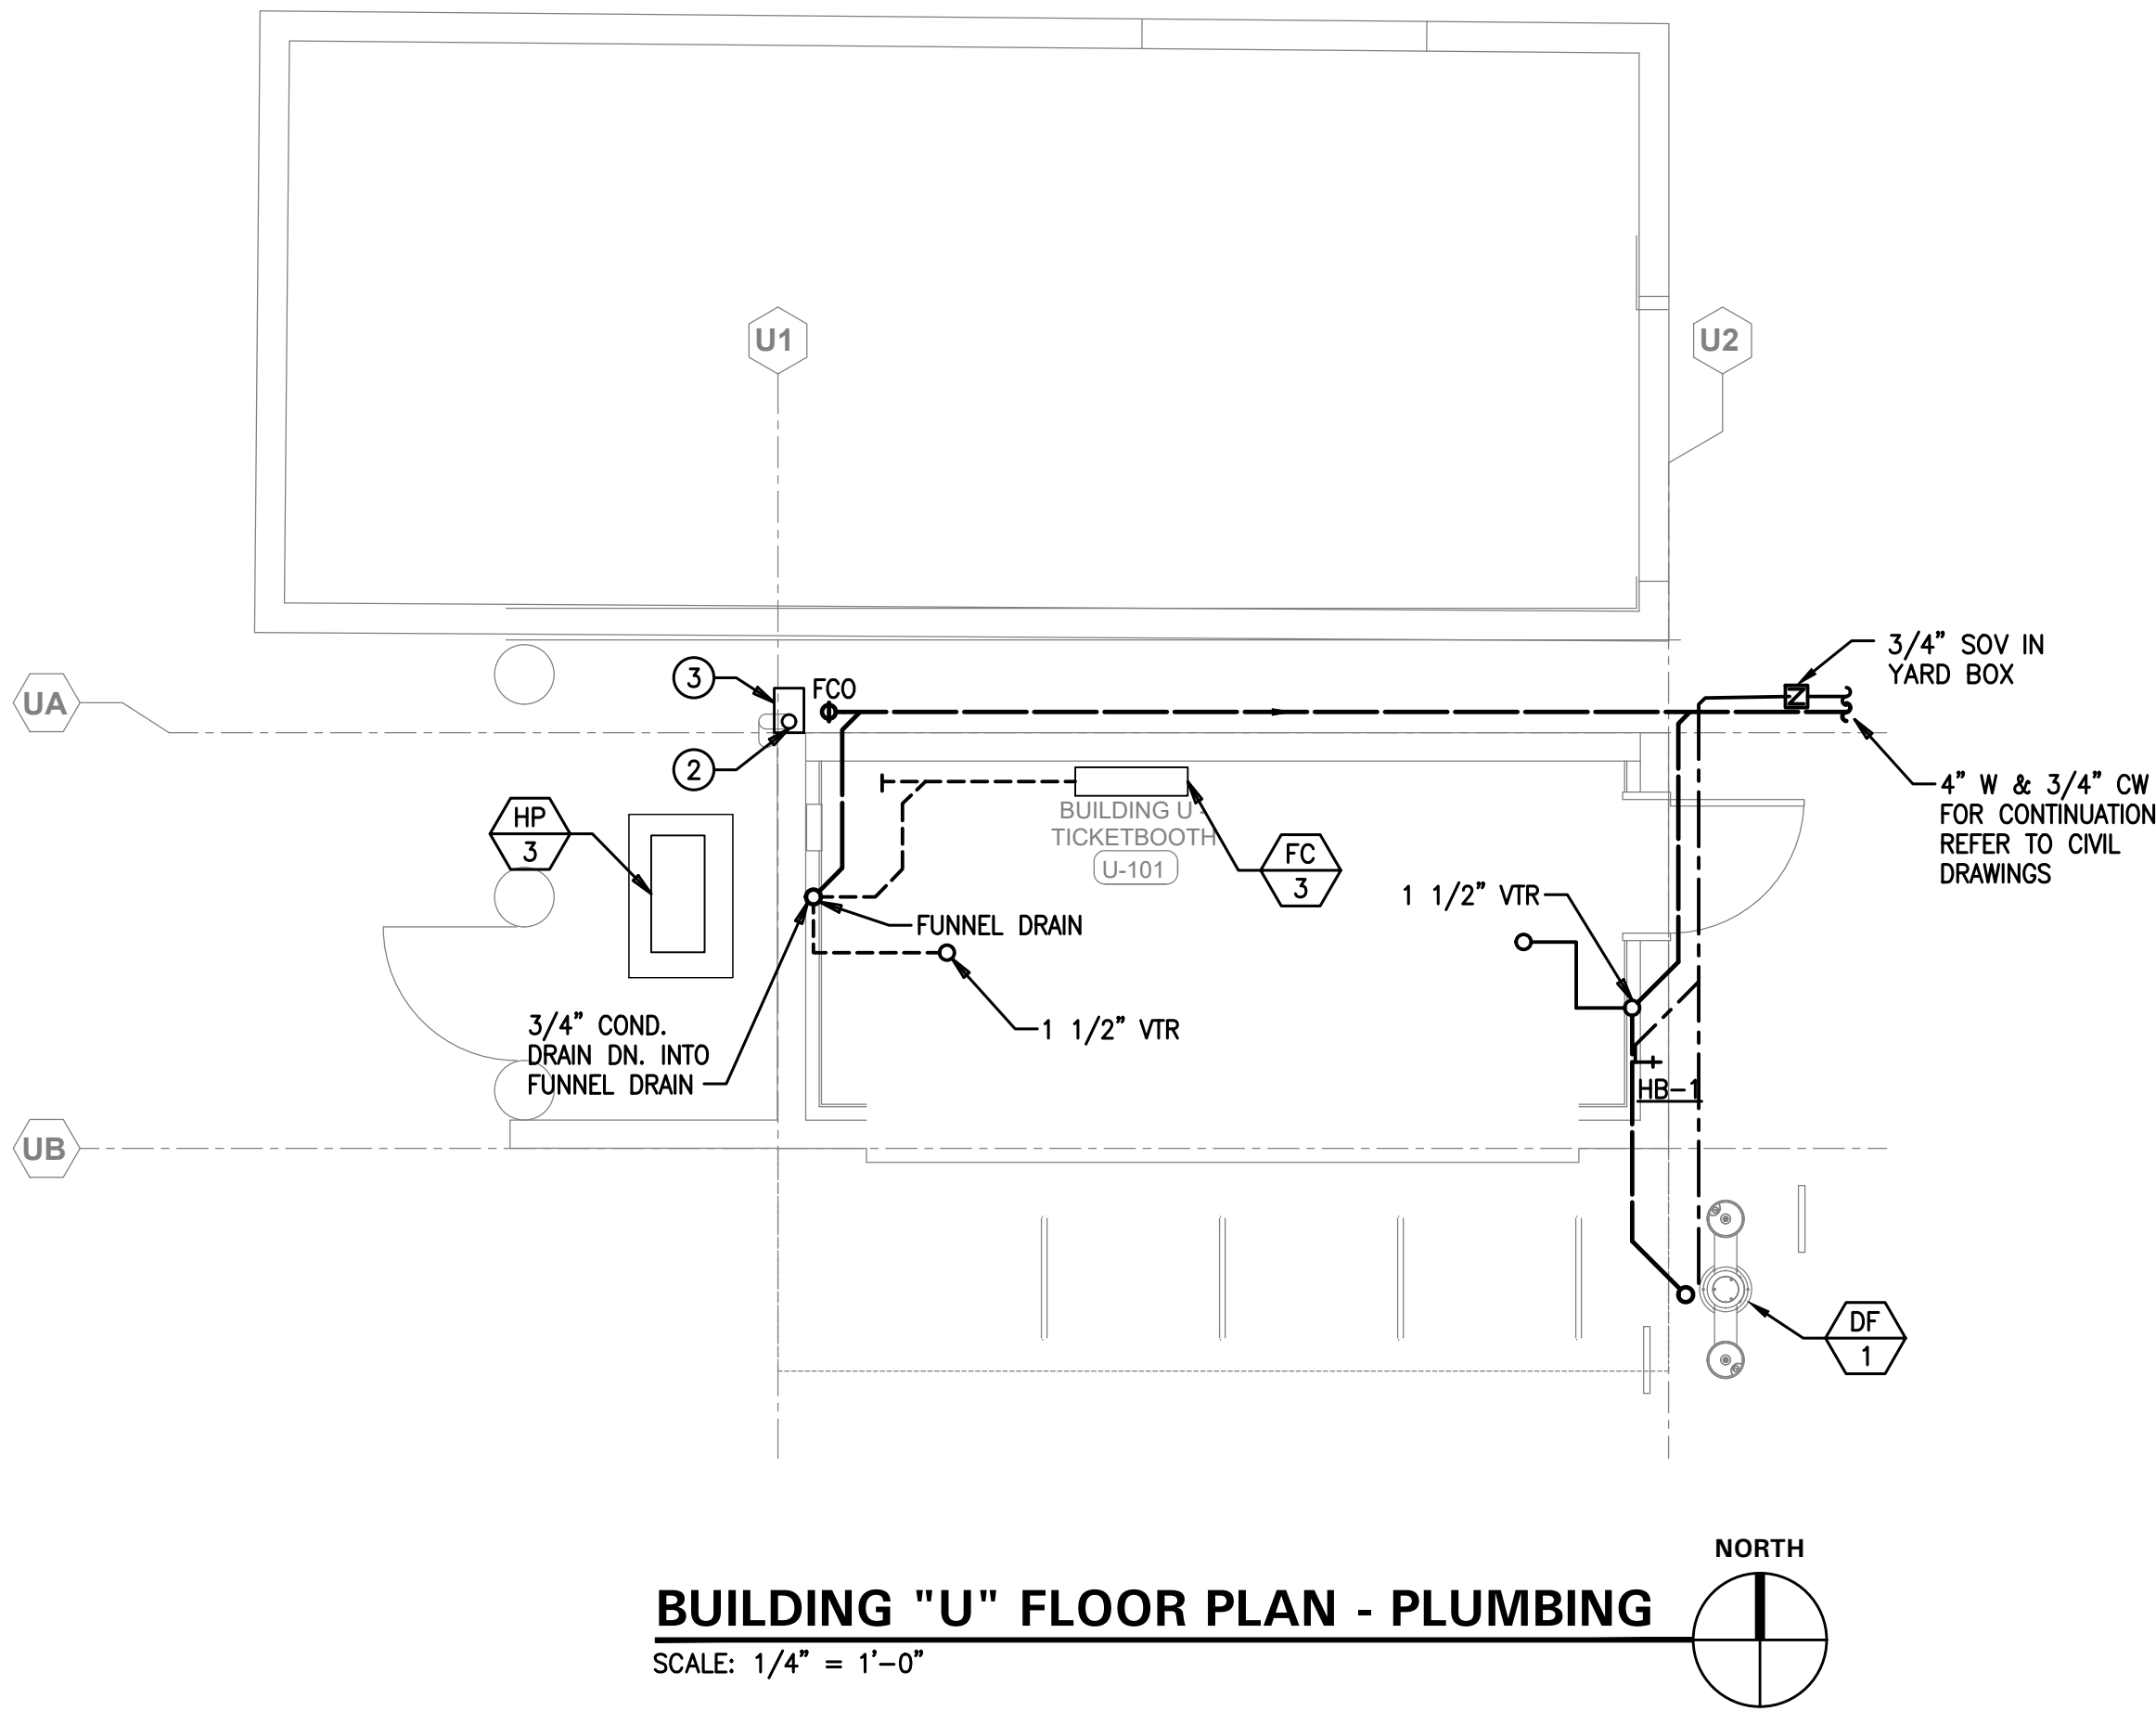

BUILDING "U" FLOOR PLAN - PLUMBING
SCALE: 1/4" = 1'-0"

NORWALK LA MIRADA UNIFIED SCHOOL DISTRICT
LA MIRADA HIGH SCHOOL NEW FOOTBALL STADIUM PROJECT
13520 ADELEFA DRIVE, LA MIRADA, CA 90638

DSA # 03-120551

NAC
ARCHITECTURE

NAC NO. 161-19015
DATE 12/10/2020

DSA BACKCHECK
SUBMISSION

FLOOR PLANS
BUILDING "U" -
PLUMBING

P8.01