



REVISIONS



1909B.MOD  
TURPIN & RATTAN  
ENGINEERING, INC.  
CONSULTING ENGINEERS  
14000 S. DEER AVE., SUITE 200  
MONTROSE, CA 91328-1855  
818 / 249 / 0444 FAX 249 / 1487

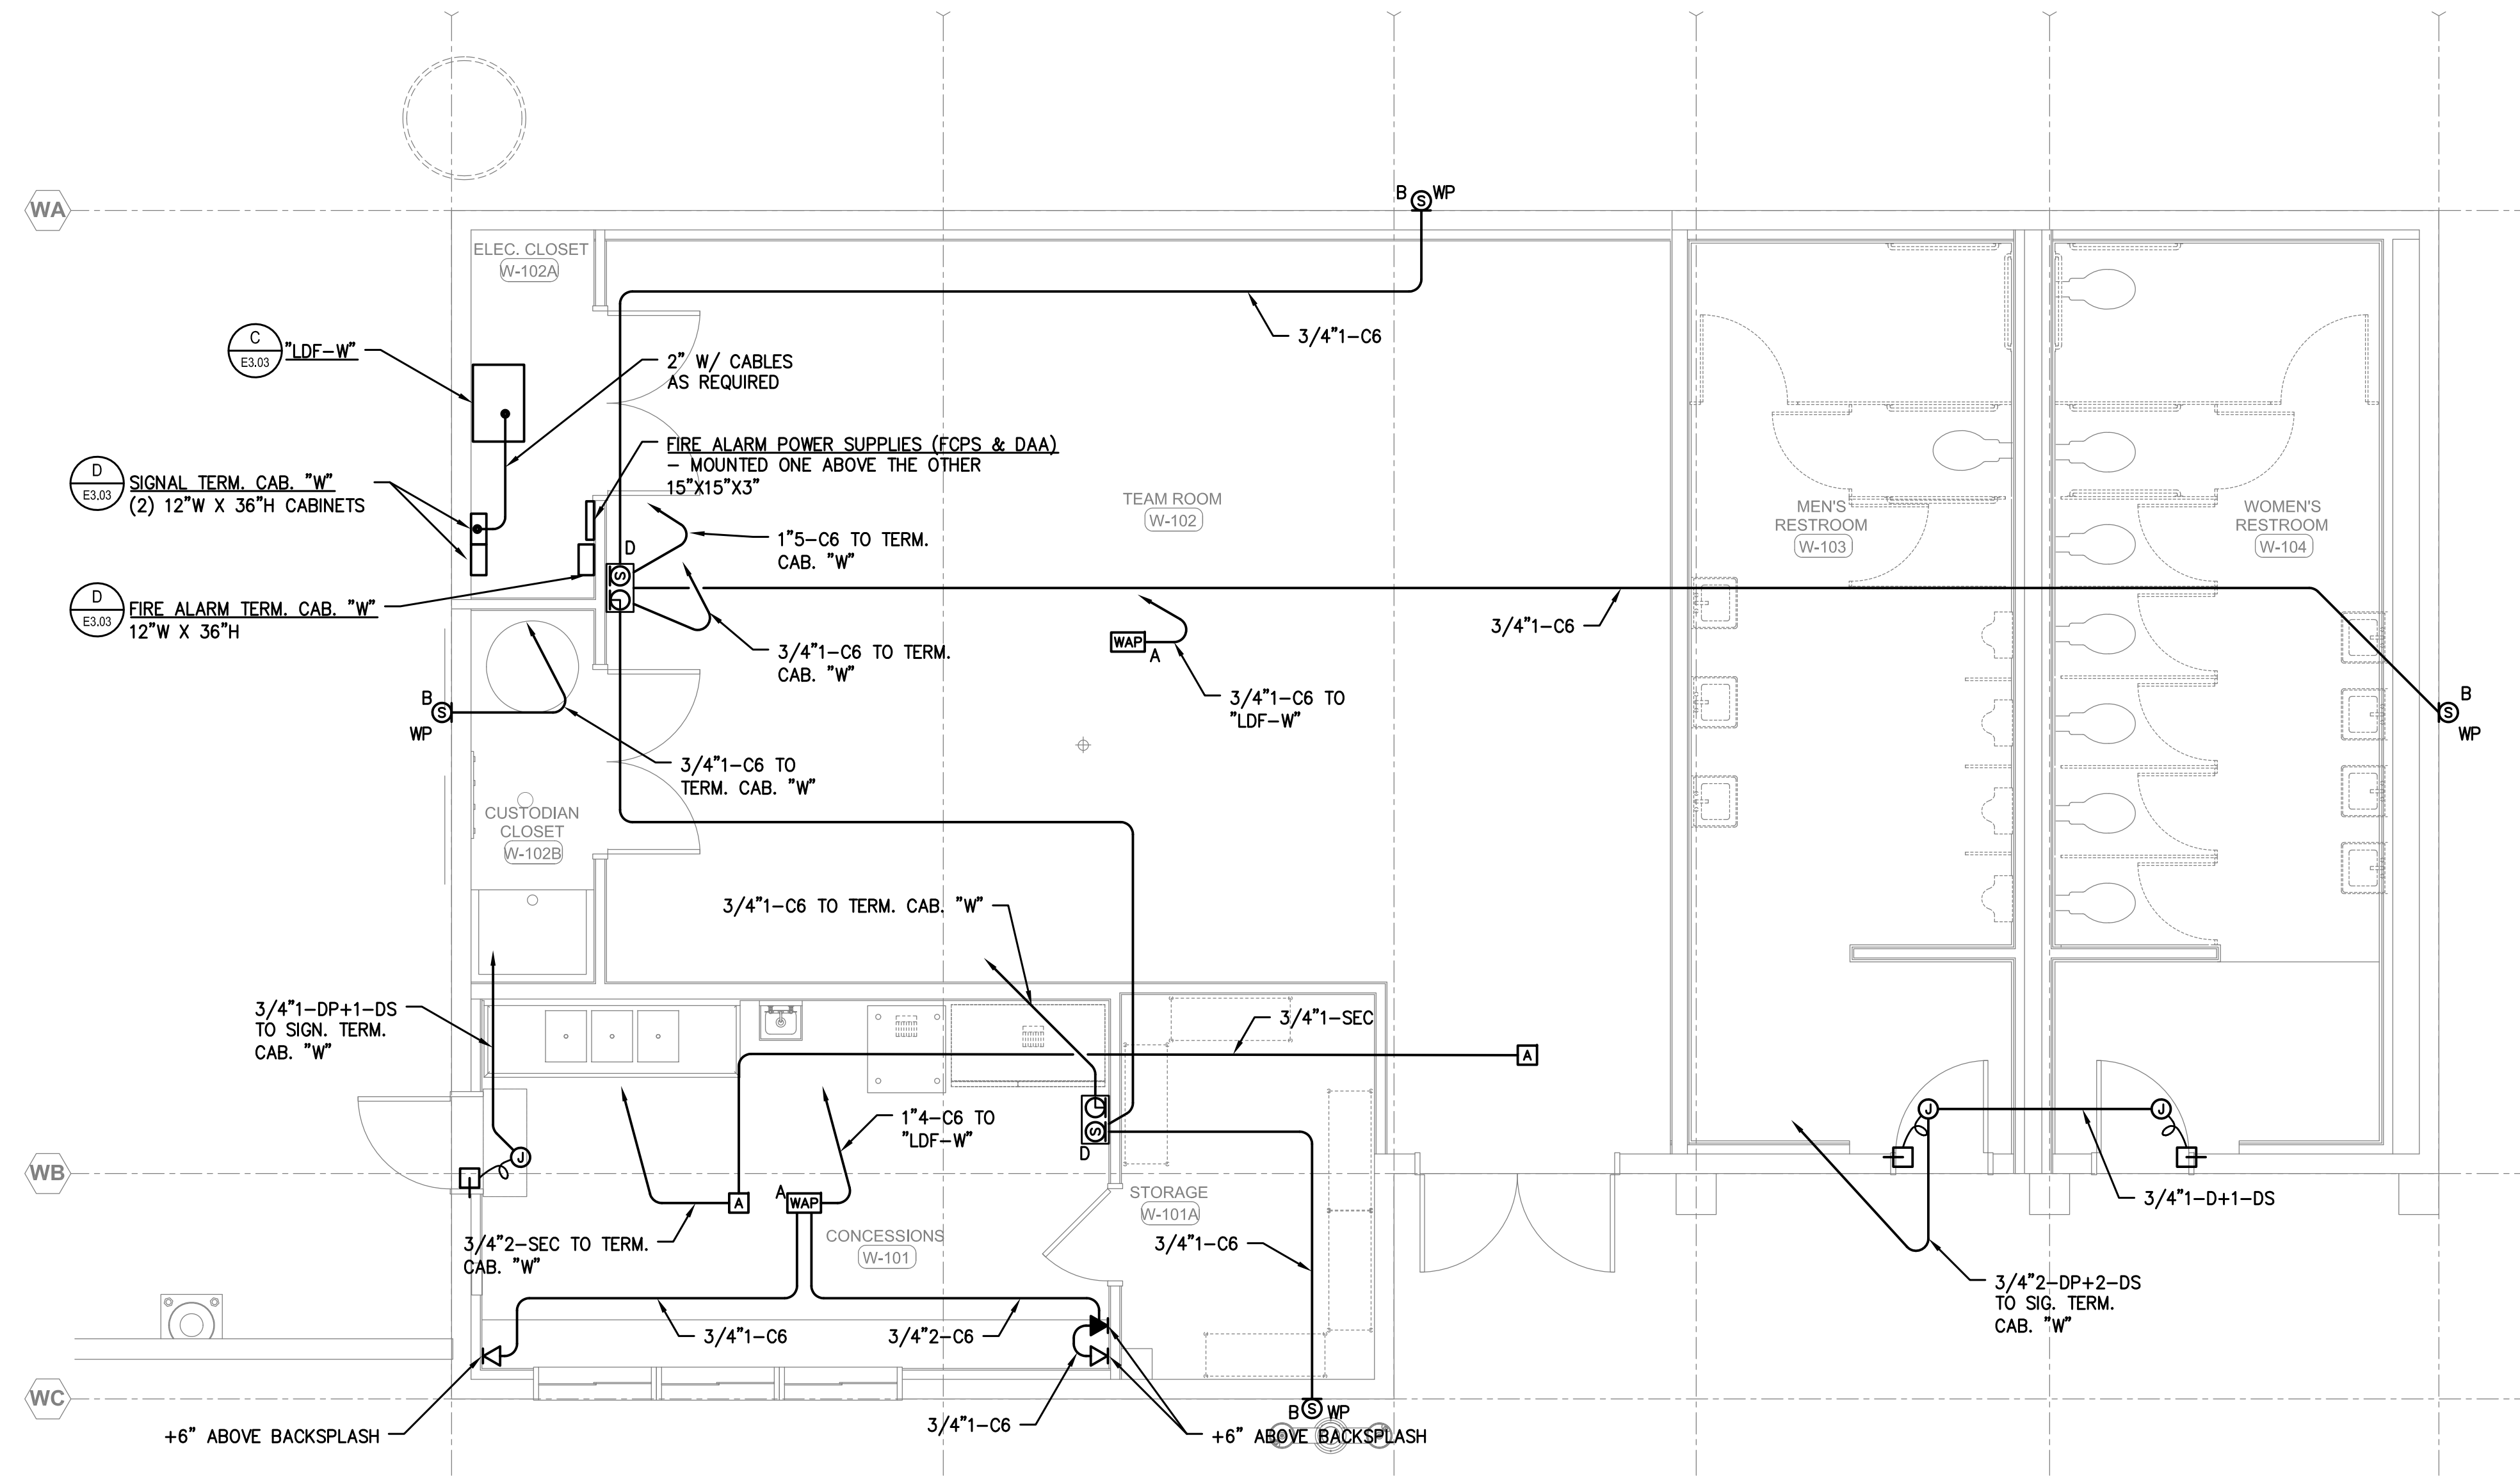

FIELDHOUSE (VISITOR) FLOOR PLAN - SIGNAL  
SCALE: 1/4" = 1'-0"

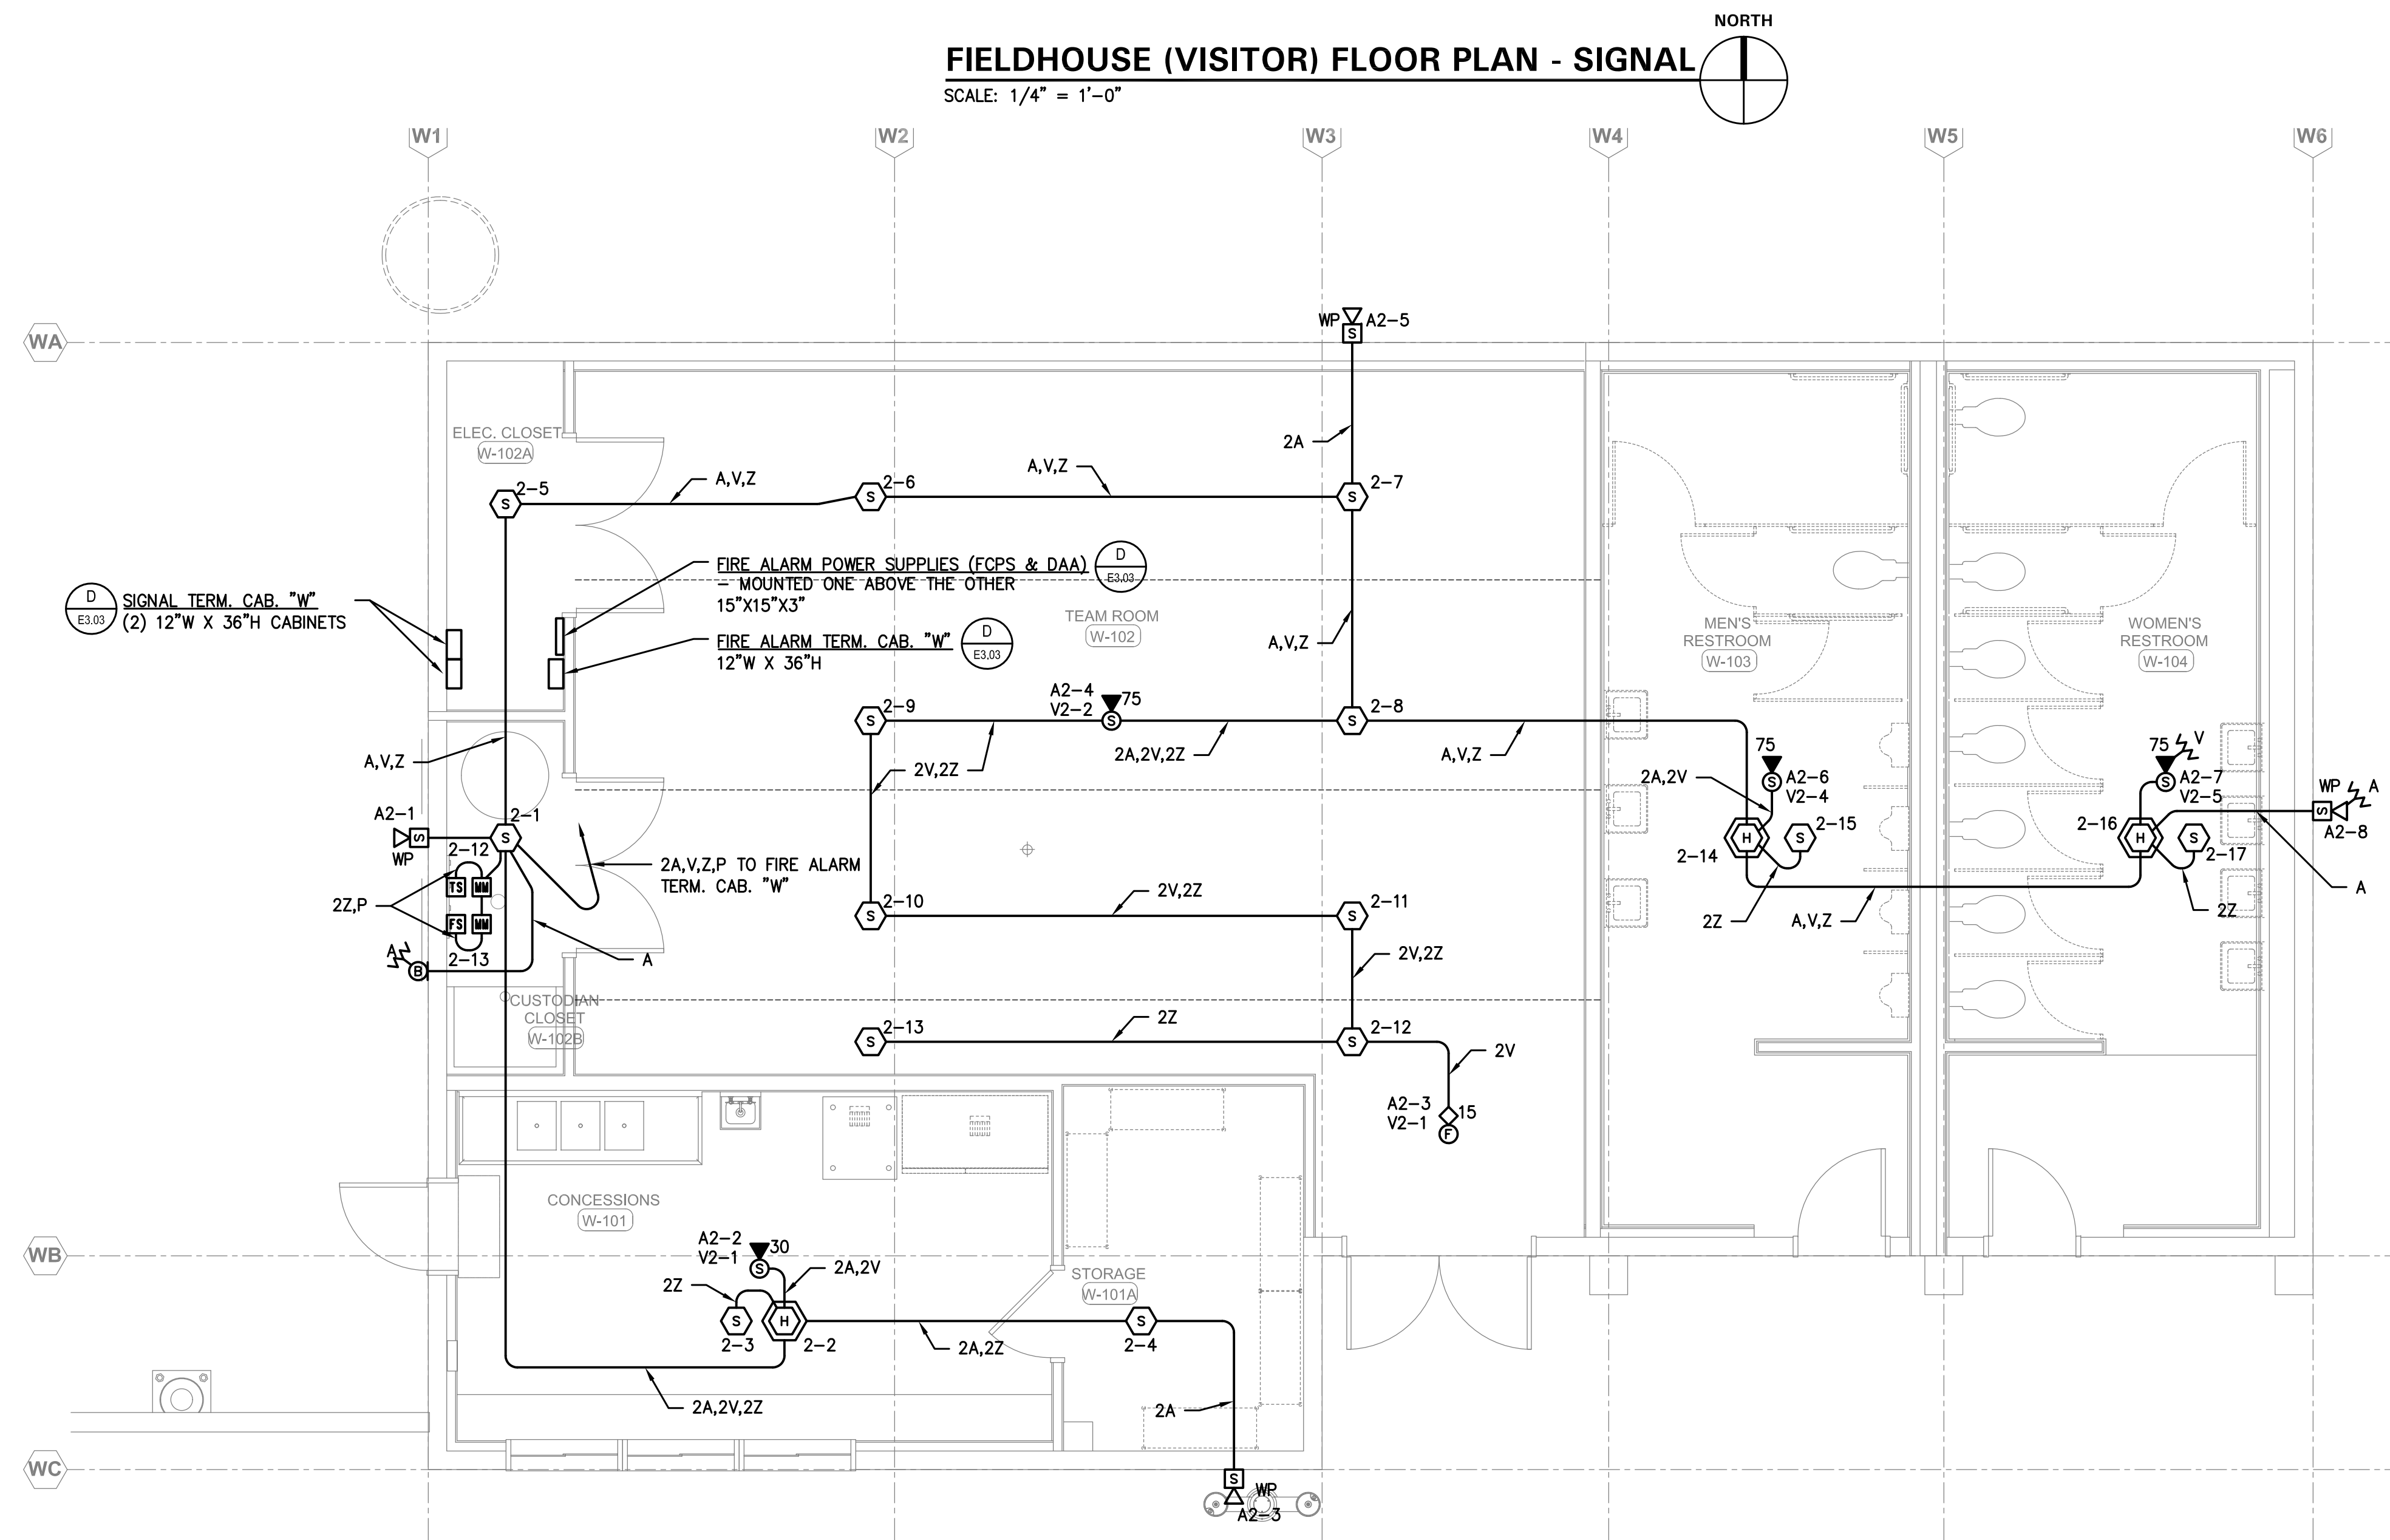

FIELDHOUSE (VISITOR) FLOOR PLAN - FIRE ALARM  
SCALE: 1/4" = 1'-0"

NOTE:  
ALL FIRE ALARM CONDUIT SHALL BE 3/4"  
MINIMUM UNLESS OTHERWISE NOTED.

NORWALK LA MIRADA UNIFIED SCHOOL DISTRICT  
LA MIRADA HIGH SCHOOL NEW FOOTBALL  
STADIUM PROJECT  
13520 ADELEFA DRIVE, LA MIRADA, CA 90638

DSA # 03-120551

NAC  
ARCHITECTURE

NAC NO. 161-19015  
DATE 12/10/2020

DSA BACKCHECK  
SUBMISSION

FLOOR PLANS  
BUILDING "W" -  
SIGNAL & FIRE ALARM

E7.04